

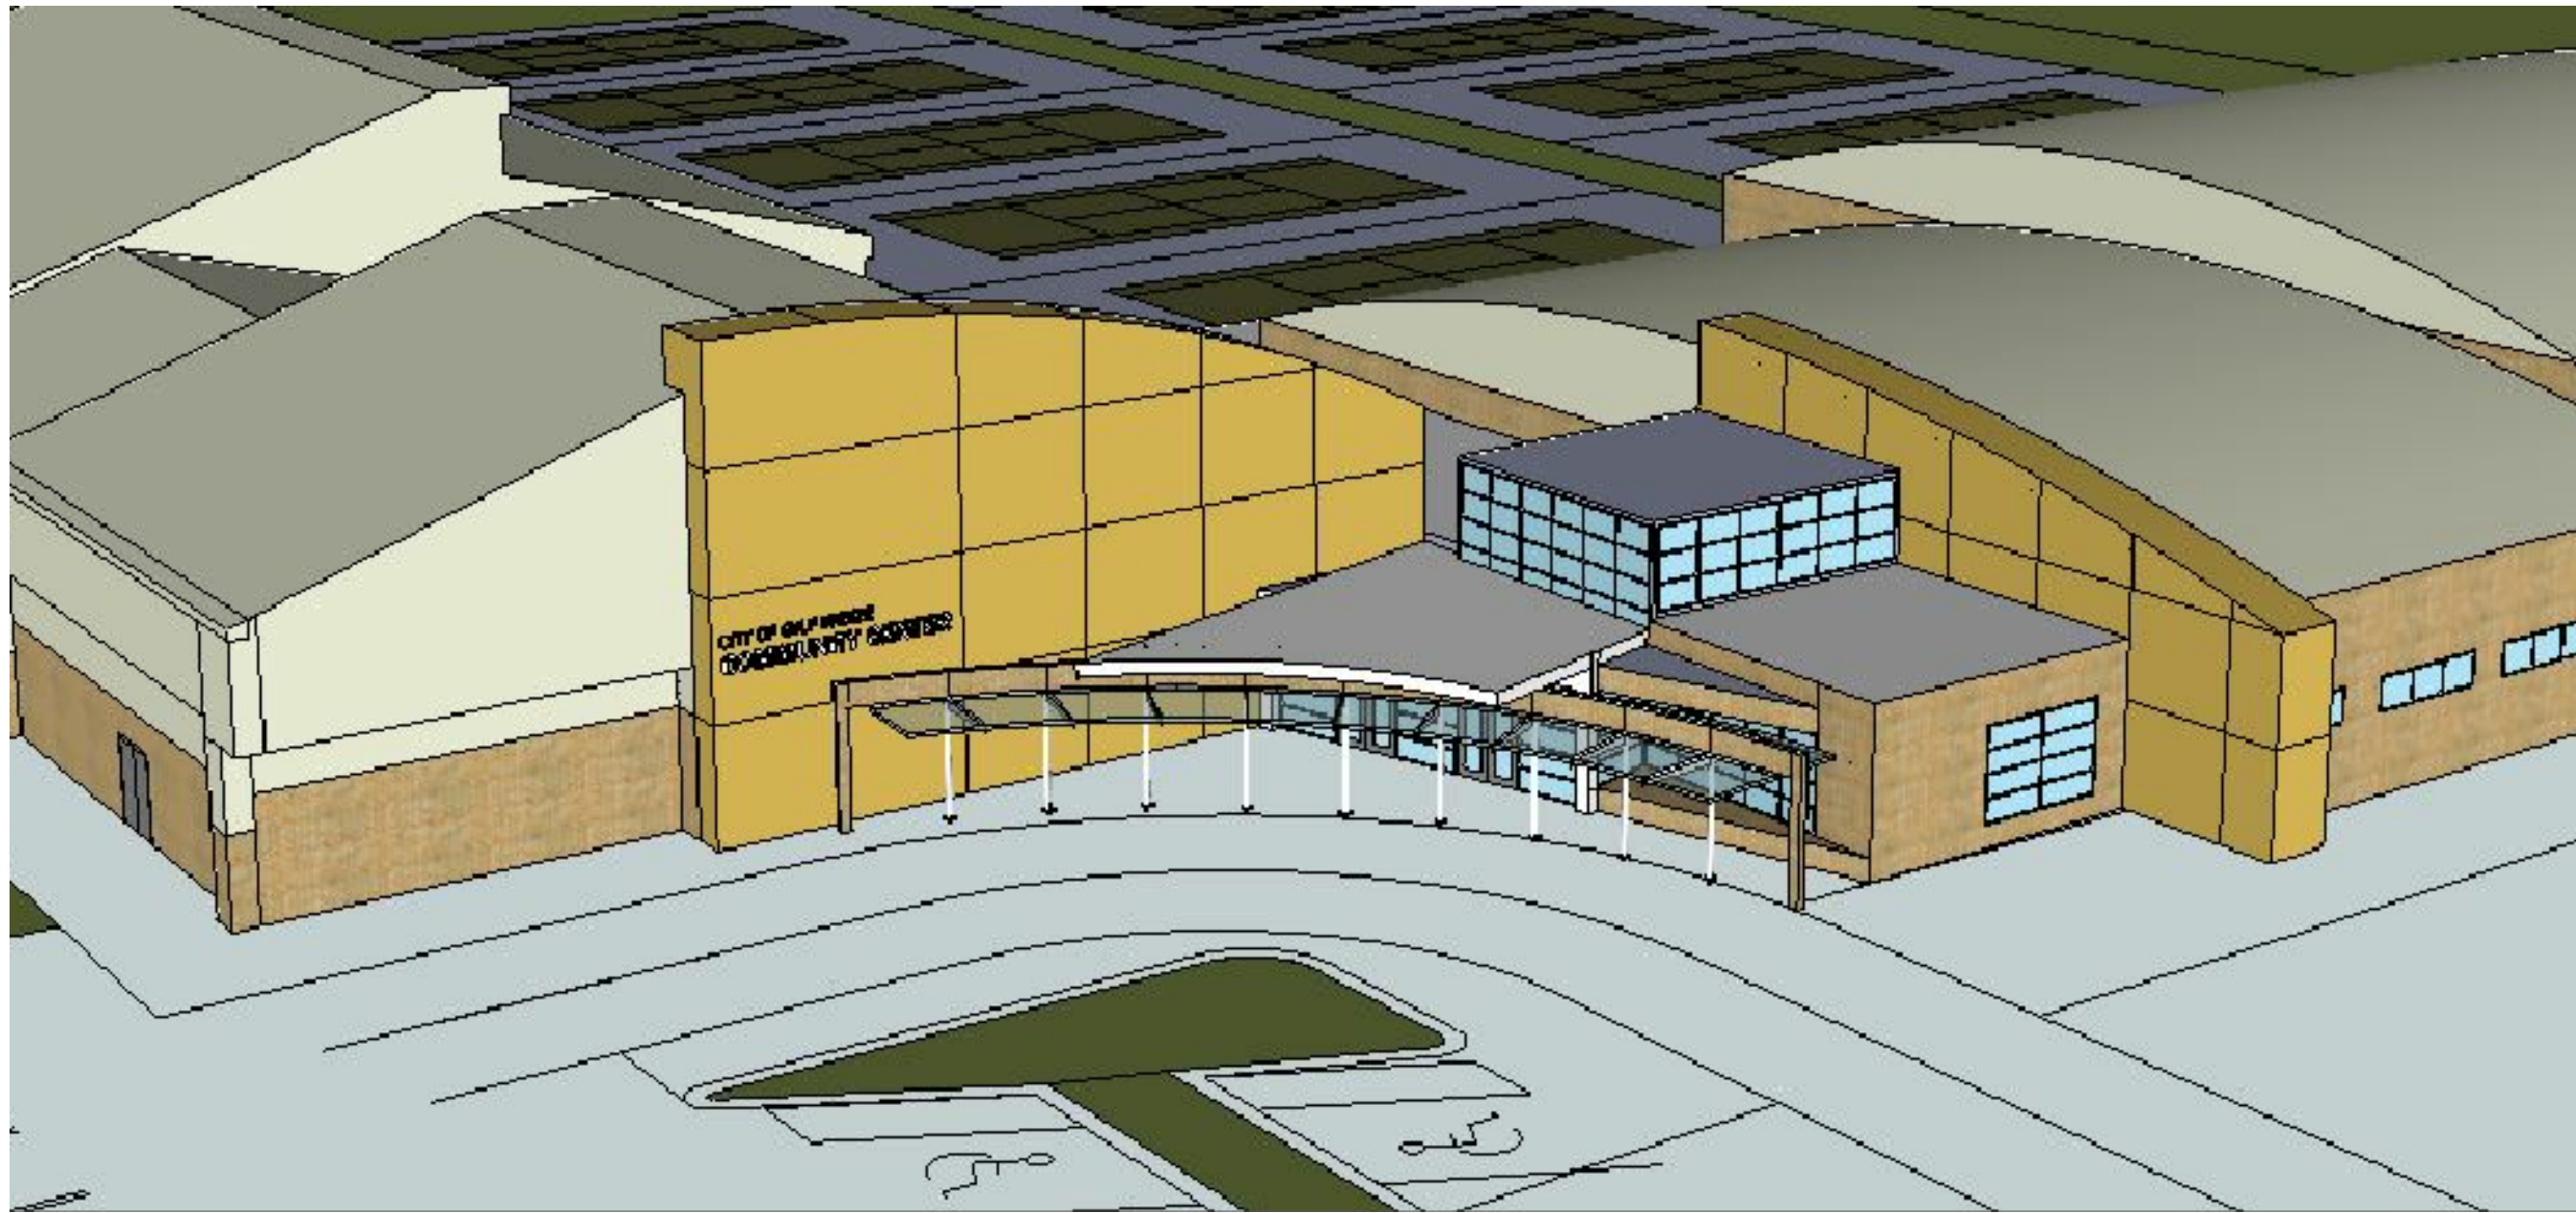


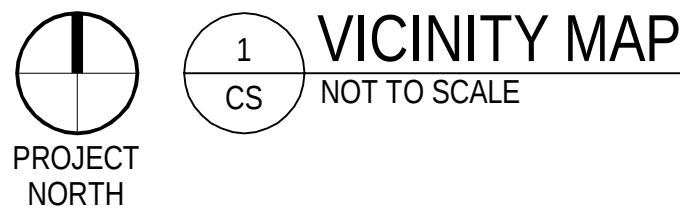

RENDERING NOT FOR CONSTRUCTION

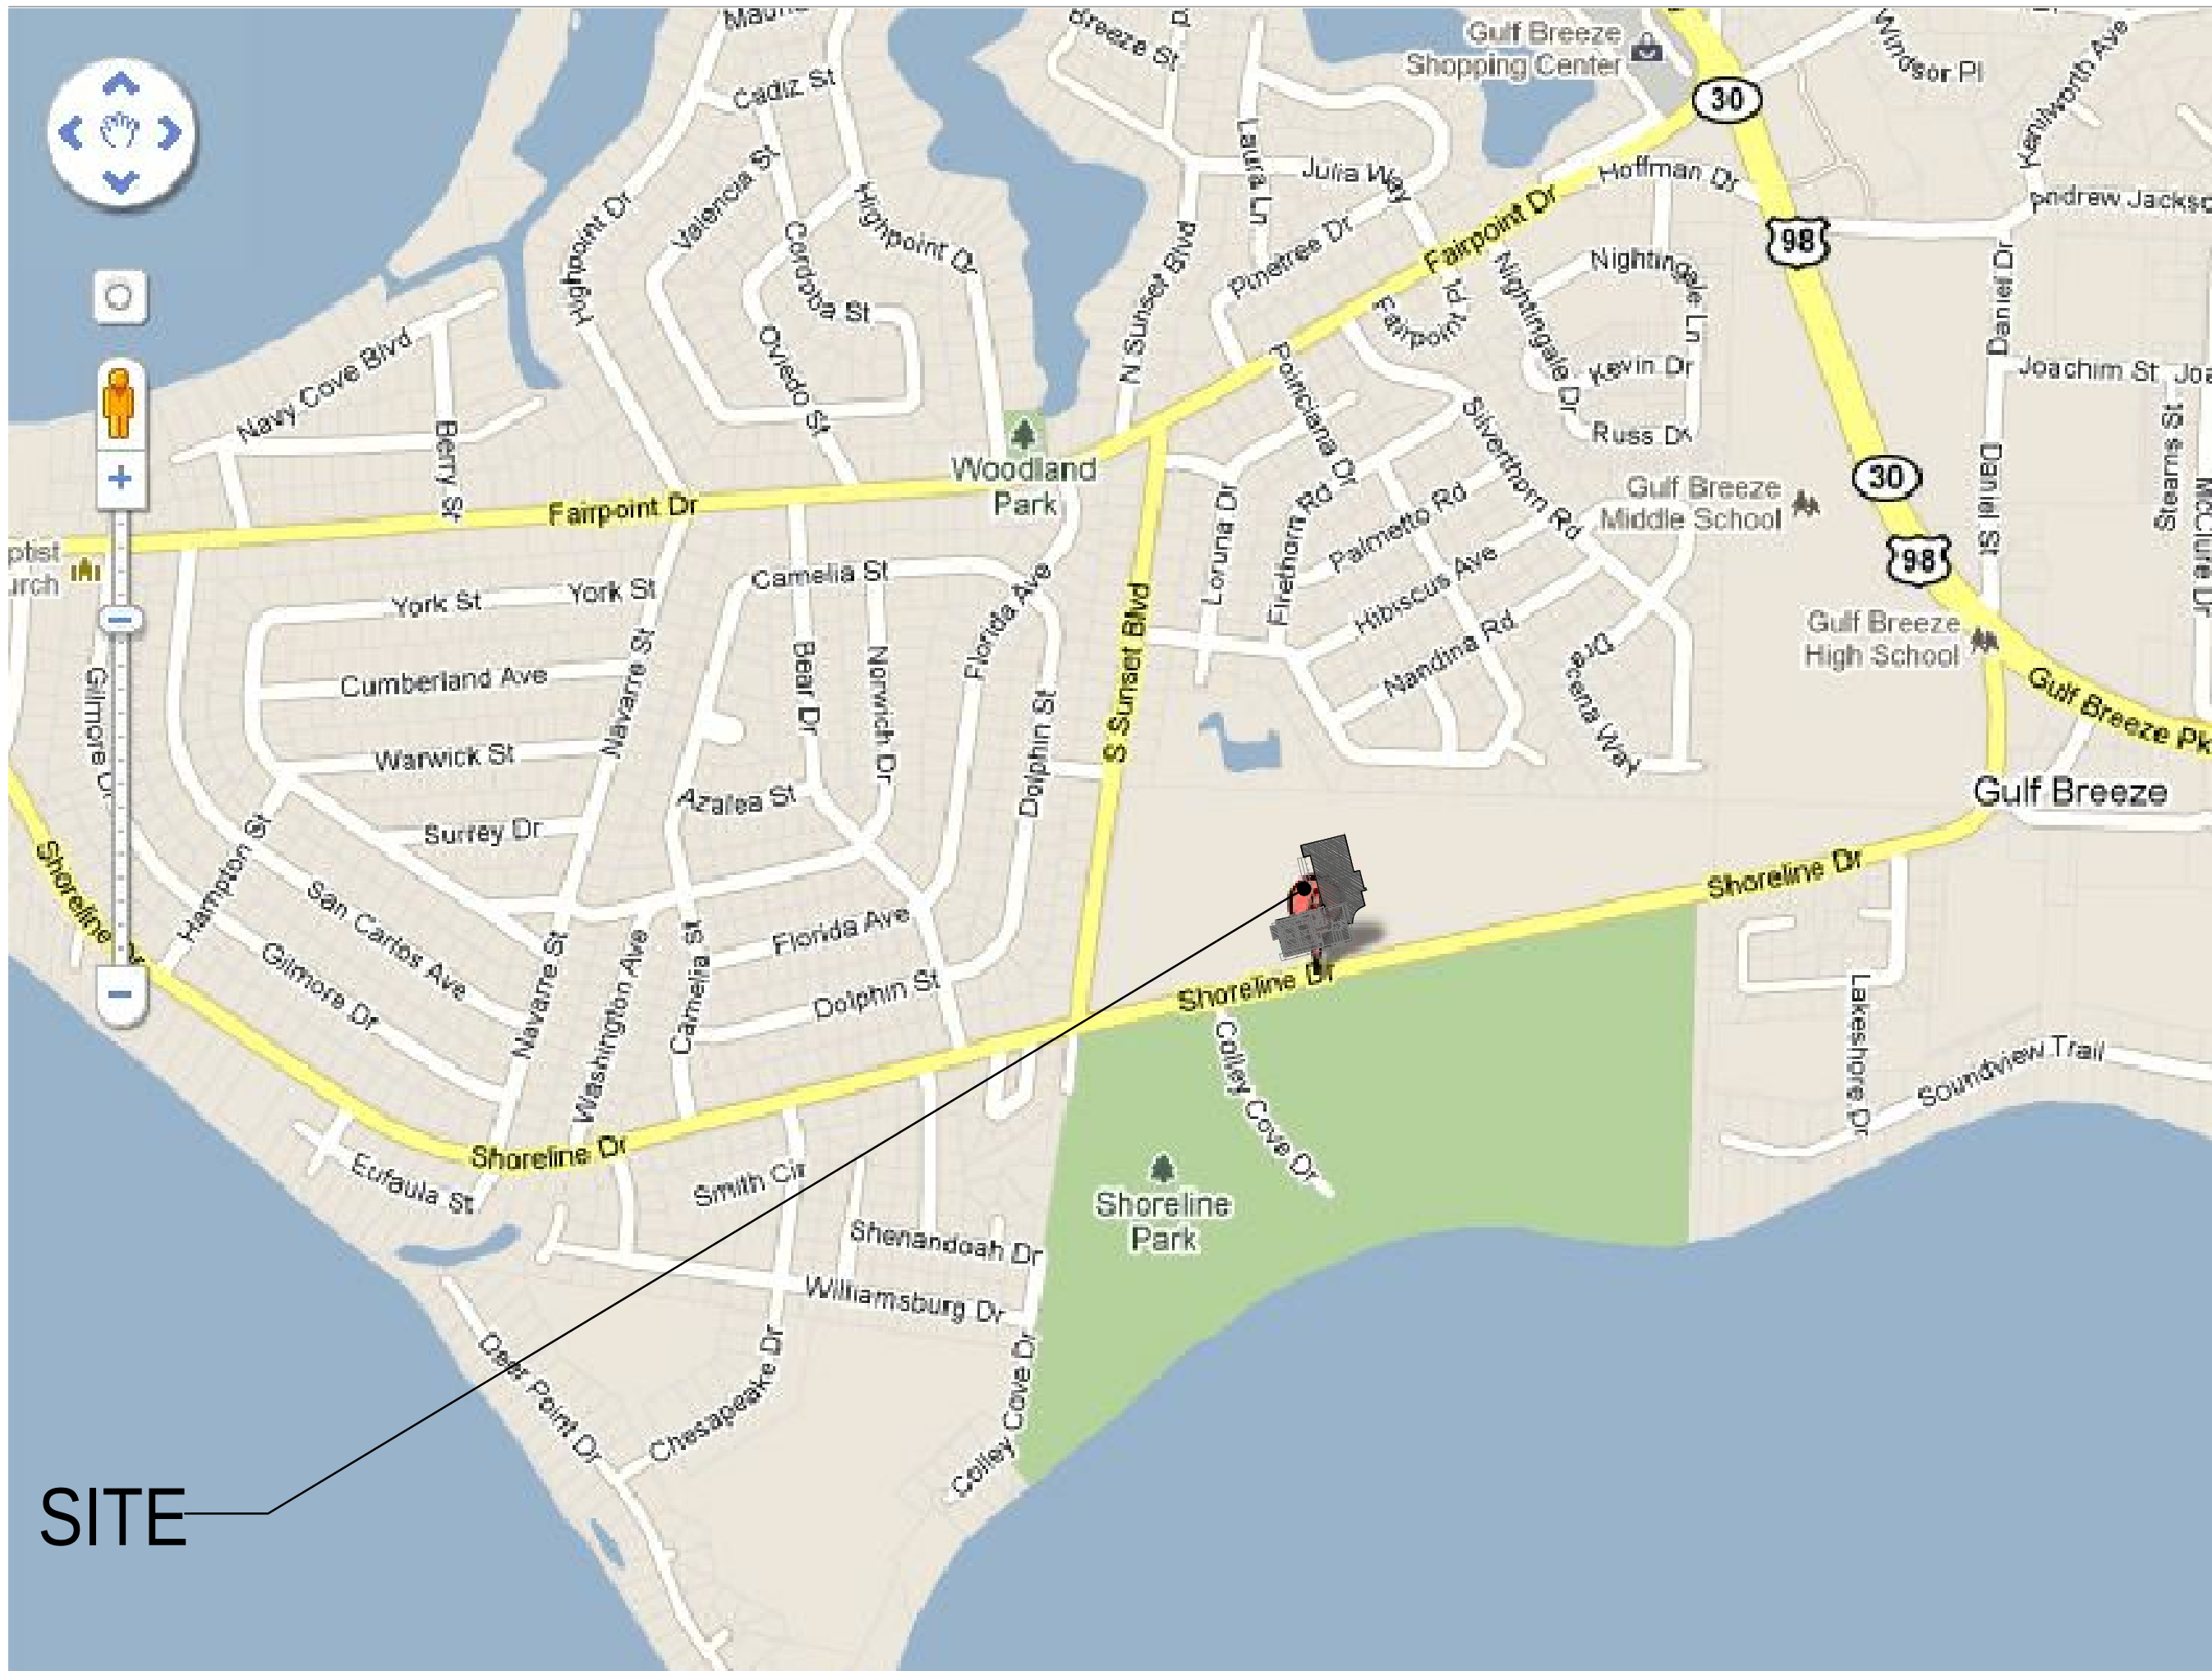

PRODUCT APPROVAL DATA				CONSULTANTS		BUILDING DATA	
CATEGORY/SUB-CATEGORY	MANUFACTURER	PRODUCT DESCRIPTION	APPROVAL No.	CIVIL:	ELECTRICAL:	CONSTRUCTION TYPE:	
DOOR/EXTERIOR SWINGING	CECO PRODUCTS	EXTERIOR HOLLOW METAL DOOR AND FRAME	FL 4553	Rebol Battle & Associates, LLC 2301 N. 9th Avenue #300 Pensacola, FL 32503 Phone: 850.438.0400 Fax: 850.438.0448	Dell Consulting LLC 129 E. Government Street Pensacola, FL 32502 Phone: 850.332.5687 Fax: 850.728.0392	FCB 2007 - TYPE II-B, FULLY PROTECTED, AUTOMATIC FIRE SUPPRESSION SYSTEM, NFPA 13 SYSTEM	SECTION 506 AREA MODIFICATION EQUATION 5-1 ALLOW. AREA / STORY = (A ₁ + (A ₂ x I)) + (A ₃ x I ₂) = (9,500 + (9,500 x .75)) + (9,500 x 3) = 9,500 + 7,125 + 28,500 = 45,125 SF ALLOW/FLOOR
WINDOWS/PANEL	KAWNEER	EXTERIOR ALUMINUM WINDOW/ STOREFRONT, ENTRANCE DOORS/FRAMES	FL 14287	STRUCTURAL:	TELECOM / AUDIO VISUAL / SECURITY :	OCCUPANCY:	FRONTAGE INCREASE (I) = [F/F - .25] W/30 = [1217/1217 - .25] 30/30 = [75] = .75 AREA INCREASE ALLOWED
ROOFING/METAL ROOFING	BERRIDGE	METAL ROOF AND WALL PANELS	FL 11159.3-R1	Berube Leonard, LLC Structural Engineers 3101 North 12th Avenue, Suite 102 Pensacola, FL 32503 Phone: 850.473.9955 Fax: 850.473.1770	Premier Engineering Group, LLC 410 West 9 Mile Road, Suite A Pensacola, FL 32534 Phone: 850.469.0405 Fax: 850.432.0905	OCCUPANCY SEPARATION:	
ROOFING/SINGLE PLY	SIKA SARNAFIL	SINGLE PLY ROOFING	FL 9274-R2			ALLOWABLE PER FBC:	
				MECHANICAL/PLUMBING/ FIRE PROTECTION:		MAX. FLOOR AREA (TABLE 503):	
CONTRACTOR SHALL MAINTAIN ON SITE THE FOLLOWING: 1. COPY OF THE PRODUCT APPROVAL, INCLUDING PERFORMANCE CHARACTERISTICS WHICH THE PRODUCT WAS TESTED AND CERTIFIED TO COMPLY WITH 2. COPY OF APPLICABLE MANUFACTURER'S INSTALLATION INSTRUCTIONS				Peterson Engineering, Inc. 75 South F Street Pensacola, FL 32502 Phone: 850.434.0513 Fax: 850.434.9674		ACTUAL:	
PRODUCT SUBSTITUTION SHALL BE MADE SUBJECT TO FULL COMPLIANCE WITH THE CRITERIA NOTED HEREON, AND SUCH SUBSTITUTION SHALL BE SUBJECT TO PRIOR APPROVAL BY THE DESIGN PROFESSIONAL AND THE LOCAL BUILDING AUTHORITY HAVING JURISDICTION						MAX. BUILDING HEIGHT (TABLE 503):	
						TOTAL FLOOR AREA:	
						EGRESS:	
						MAX. DISTANCE OF TRAVEL ALLOWABLE	GROUP "A" = 250'
						OCCUPANCY: GROUP "A" : 15 SF/PERSON GYMS & MULTIPURPOSE ROOMS @ 28,581 SF = 1,906	
						EXIT CORRIDORS NOT REQUIRED TO BE RATED PER TABLE 1017.1(C). (NON-RATED/SMOKE PARTITIONS ONLY)	

CITY OF GULF BREEZE COMMUNITY CENTER ADDITIONS & RENOVATIONS

800 SHORELINE DRIVE
GULF BREEZE, FL 32561

INDEX OF DRAWINGS

Civil

CS	Cover Sheet
C0.1	Overall Existing Site
C0.2	Overall Site Layout & Landscape Plan
C0.3	Tree Chart & General Notes
C0.4	Erosion Control Details
C0.5	NPDES-Stormwater Pollution Prevention Plan
C1.0	Phase 1 Existing Site, Demolition & Erosion Control Plan
C1.1	Phase 1 Site Layout & Dimension Plan
C1.2	Phase 1 Grading & Drainage Plan
C1.3	Phase 1 Utility Plan
C2.0	Phase 2 Existing Site, Demolition & Erosion Control Plan
C2.1	Phase 2 Existing Site, Demolition & Erosion Control Plan
C2.2	Phase 2 Site Layout & Dimension Plan
C2.3	Phase 2 Site Layout & Dimension Plan
C2.4	Phase 2 Grading & Drainage Plan
C2.5	Phase 2 Grading & Drainage Plan
C2.6	Phase 2 Utility Plan
C3.0	Phase 3 Existing Site, Demolition & Erosion Control Plan
C3.1	Phase 3 Site Layout & Dimension Plan
C4.0	Site Details
C4.1	Site Details
C4.2	Grading & Drainage Details
C4.3	Utility Details

Structural

S001	General Notes & Typical Details
S101	Building 'A' Foundation Plan
S201	Building 'A' Entry Canopy, Mezzanine , & Covered Porch Roof Framing Plans
S202	Building 'A' Roof Framing & Bottom Chord Bracing Plans
S203	Building 'A' High Lobby & Gym Roof Framing Plans
S301	Foundation Sections and Details
S401	Sections and Details
S402	Sections and Details
S403	Sections and Details
S404	Sections and Details
S405	Sections and Details
S406	Sections and Details
S501	Truss Elevation and Details
S502	Framing Elevations
S503	Drop-off Canopy Plans and Details

Architectural

D100	Building "B" Demolition - Ground Level Floor Plan
D110	Demolition - Ground Level Reflected Ceiling Plan
D120	Building "B" Demolition Roof Plan
D200	Building "B" Demolition - Exterior Elevations
D201	Building "B" Demolition - Exterior Elevations
A001	Phasing / Construction Coordination Plan
A100	Overall Building & Sidewalk Plan
A101	Building "A" - Ground Level Floor Plan
A102	Building "A" - Mezzanine Level Floor Plan
A103	Building "B" New Work - Ground Level Floor Plan
A104	Building "B" New Work - Mezzanine Level Floor Plan
A110	Building "A" - Ground Level Reflected Ceiling Plan
A111	Building "B" New Work - Ground Level Floor Plan
A120	Building "A" - Roof Plan
A121	Building "B" New Work Roof Plan
A130	Overall Floor Finish Plan
A200	Building "A" Exterior Elevations
A201	Building "B" Exterior Elevations
A202	Building "B" Exterior Elevations - New Work
A300	Building "A" - Building Sections
A301	Building "A" - Building Sections
A302	Building "A" - Building Sections
A310	Wall Sections
A311	Wall Sections
A312	Wall Sections
A320	Details
A321	Details
A322	Details
A323	Details
A324	Details
A325	Details
A326	Details
A327	Details
A328	Details
A400	Bldg "A" - Enlarged Kitchen Floor Plan
A401	Bldg "A" - Enlarged Gymnasium Plan
A402	Bldg "A" - Enlarged Entry Plan
A410	Bldg "A" - Enlarged Toilet Plan, Accessories & Elevations
A430	Wall Types
A440	Stairs #1,2 Plans, Sections & Details
A460	Casework
A510	Door, Window & Storefront Elevations
A511	Door & Window Details
A512	Door & Window Details
A513	Door & Window Details
A514	Door & Window Details
A600	Door & Window Schedules, Finish Schedule
A700	Typical Standing Seam Metal Roof Details

Plumbing

P101	Plumbing Plan New Work
P102	Enlarged Plumbing Plan - New Work - Restroom - Waste and Water
P103	Enlarged Plumbing Plan - New Work - Kitchen - Waste and Water
P104	Details & Schedules
P105	Riser Diagrams
M001	Mechanical General Notes & Legend
M101	Mechanical Demolition Plan
M111	Mechanical New Work Plan
M112	Mecahnical New Work Plan
M121	Mechanical New Work Piping Plan
M122	Mechanical New Work Piping Plan
M123	Mechanical Site Plan
M301	Mechanical Section
M302	Mechanical Sections
M303	Mechanical Sections
M401	Mechanical Large Scale Plans
M402	Mechanical Large Scale Plans
M501	Mechanical Details
M502	Mechanical Details
M503	Mechanical Details
M601	Mechanical Schedules
M701	Mechanical DDC Controls
M702	Mechanical DDC Controls

Fire Protection

FP101	Fire Protection Plan - New Work
FP301	Fire Protection Sections

Electrical

E010	Legend, Notes & Abbreviations
E020	Site Plan - Phase I Electrical Demolition
E021	Site Plan - Phase I Electrical New Work
E022	Site Plan - Phase II Electrical
E101	First Floor Plan - Demo
E111	Bldg 'A' First Floor Plan - Lighting
E112	Bldg 'B' First Floor Plan - Lighting
E113	Mezzanine Plans - Lighting
E121	Building 'A' First Floor Plan - Power
E122	Building 'B' First Floor Plan - Power
E123	Mezzanine Floor Plans - Power
E131	Building 'A' First Floor Plan - Fire Alarm
E132	Building 'B' First Floor Plan - Fire Alarm
E133	Mezzanine Floor Plan - Fire Alarm
E200	Details

Electrical CONT'D


E300	Single Line Diagram
E301	Lighting Control Riser Diagram
E400	Schedules
E401	Schedules

Telecommunications

TEL101	Communications Ground Level Floor Plan
TEL102	Communications Demolition Floor Plan
TEL201	Communications Typical Details
TEL202	Intercom/PA Notes & Typical Details
TEL203	Communications Typical Labeling Details
TEL301	Voice System Single Line Configuration Diagram
TEL302	Data/TV System Single Line Configuration Diagram
TEL303	IP Security Camera System Single Line Diagram
TEL304	Data/TV System Single Line Configuration Diagram
TEL305	Intercom/PA System Detailed Wiring Diagram - Part 1
TEL306	Intercom/PA System Detailed Wiring Diagram - Part 2
TEL401	CER Enlarged Floor Plans & Rack Elevations

Audiovisual

AV-1	AV Floor Plan - Gym 001
AV-2	AV Floor Plan - Multipurpose Rooms
AV-3	AV Floor Plan - Gym 116
AV-4	AV Reflected Ceiling - Gym 001
AV-5	AV Reflected Ceiling - Multipurpose Rooms
AV-6	AV Reflected Ceiling - Gym 116
AV-7	AV Schematic - All Systems
AV-8	AV Schematic - Output Sections
AV-9	AV Rack Elevations
AV-10	AV Conduit Riser

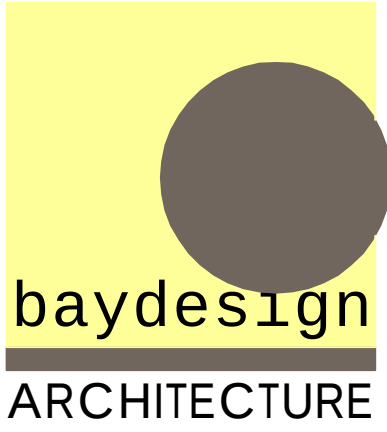

architecture + sustainability
720 bayfront parkway
suite 200
pensacola, fl 32502
t: 850.432.0706
f: 850.433.0508
baydesign.com

SEAL
Steve Jernigan, FAIA FL#9953, AL#2676, GA#RA011516, MS#4135, CO#400232
bay design associates architects, pl florida certificate of authorization AA003597
PROJECT: Gulf Breeze Community Center 800 Shoreline Drive Gulf Breeze, FL 32561
SHEET TITLE: Cover Sheet
PROJECT NO: 2413 FILE NO: 2413_CS DATE: 06.01.2011 REVISION:
SHEET CS