


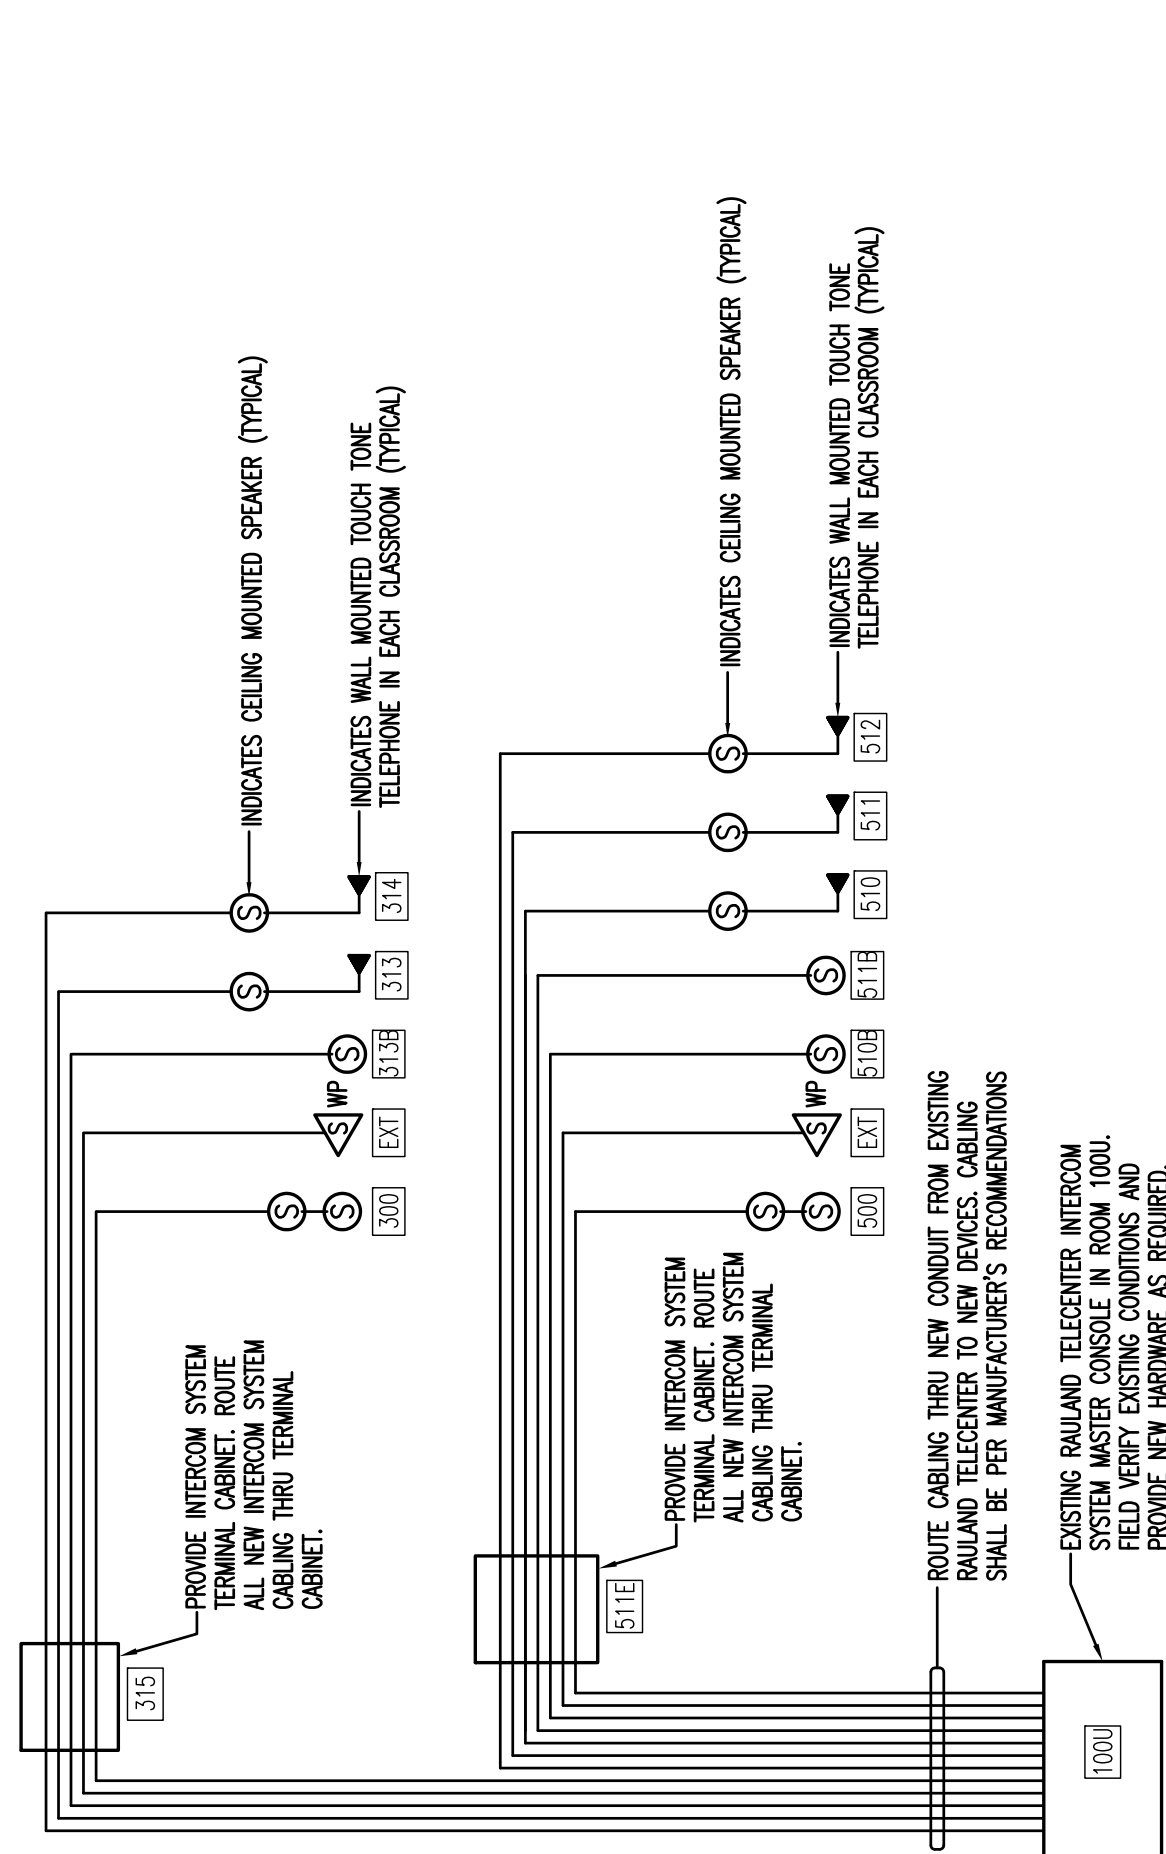


INTERCOM SYSTEM RISER DIAGRAM

SCALE: NONE

INTERCOM SYSTEM GENERAL NOTES

- EXISTING INTERCOM MASTER CONSOLE IS A RAULAND TELECENTER SYSTEM.
- IN ADDITION TO PROVIDING NEW DEVICES AS INDICATED ON THE PLANS, PROVIDE NEW POWER SUPPLIES, AMPLIFIERS, SWITCHBANKS, INTERCOM CABLEING, INTERCOM HOMERUNS, ETC AS REQUIRED TO MAINTAIN A COMPLETELY FUNCTIONAL INTERCOM SYSTEM.
- ALL CABLEING SHALL BE NEW AND SHALL BE PER MANUFACTURER'S RECOMMENDATIONS. ALL INTERCOM CABLEING SHALL BE INSTALLED IN CONDUIT.
- T-TAPPING SHALL NOT BE PERMITTED.
- THE CONTRACTOR SHALL PERFORM A COMPLETE PREWORK INSPECTION AND TEST OF THE EXISTING INTERCOM SYSTEM PRIOR TO CONSTRUCTION. THE CONTRACTOR SHALL NOTIFY THE ARCHITECT AND OWNER IN WRITING OF ANY EXISTING TROUBLES PRIOR TO CONSTRUCTION. ANY SUCH TROUBLES PRESENT AT THE END OF CONSTRUCTION AND NOT LISTED IN THE PREWORK INSPECTION REPORT SHALL BE CORRECTED BY THE CONTRACTOR PRIOR TO OBTAINING SUBSTANTIAL COMPLETION.
- THE CONTRACTOR SHALL PROVIDE ALL DEVICES INCLUDING BUT NOT LIMITED TO POWER SUPPLIES, AMPLIFIERS, CABINETS, TELEPHONES, SPEAKERS, WIRING, CABLEING, CONDUIT, CABLE TRAY, DEVICES, ETC AND SHALL PERFORM ALL WORK ASSOCIATED WITH THE INSTALLATION OF THE INTERCOM SYSTEM AS INDICATED ON THE DRAWINGS AND SPECIFICATIONS.
- ALL NEW INTERCOM SYSTEM DEVICES INCLUDING BUT NOT LIMITED TO SPEAKERS, WALL-MOUNTED PHONES, ETC SHALL BE RAULAND AND SHALL BE PROVIDED BY RAULAND.
- PROVIDE ALL CONDUIT AND INTERCOM SYSTEM CABLEING AS REQUIRED FOR NEW TOUCH TONE TELEPHONE IN EACH CLASSROOM.

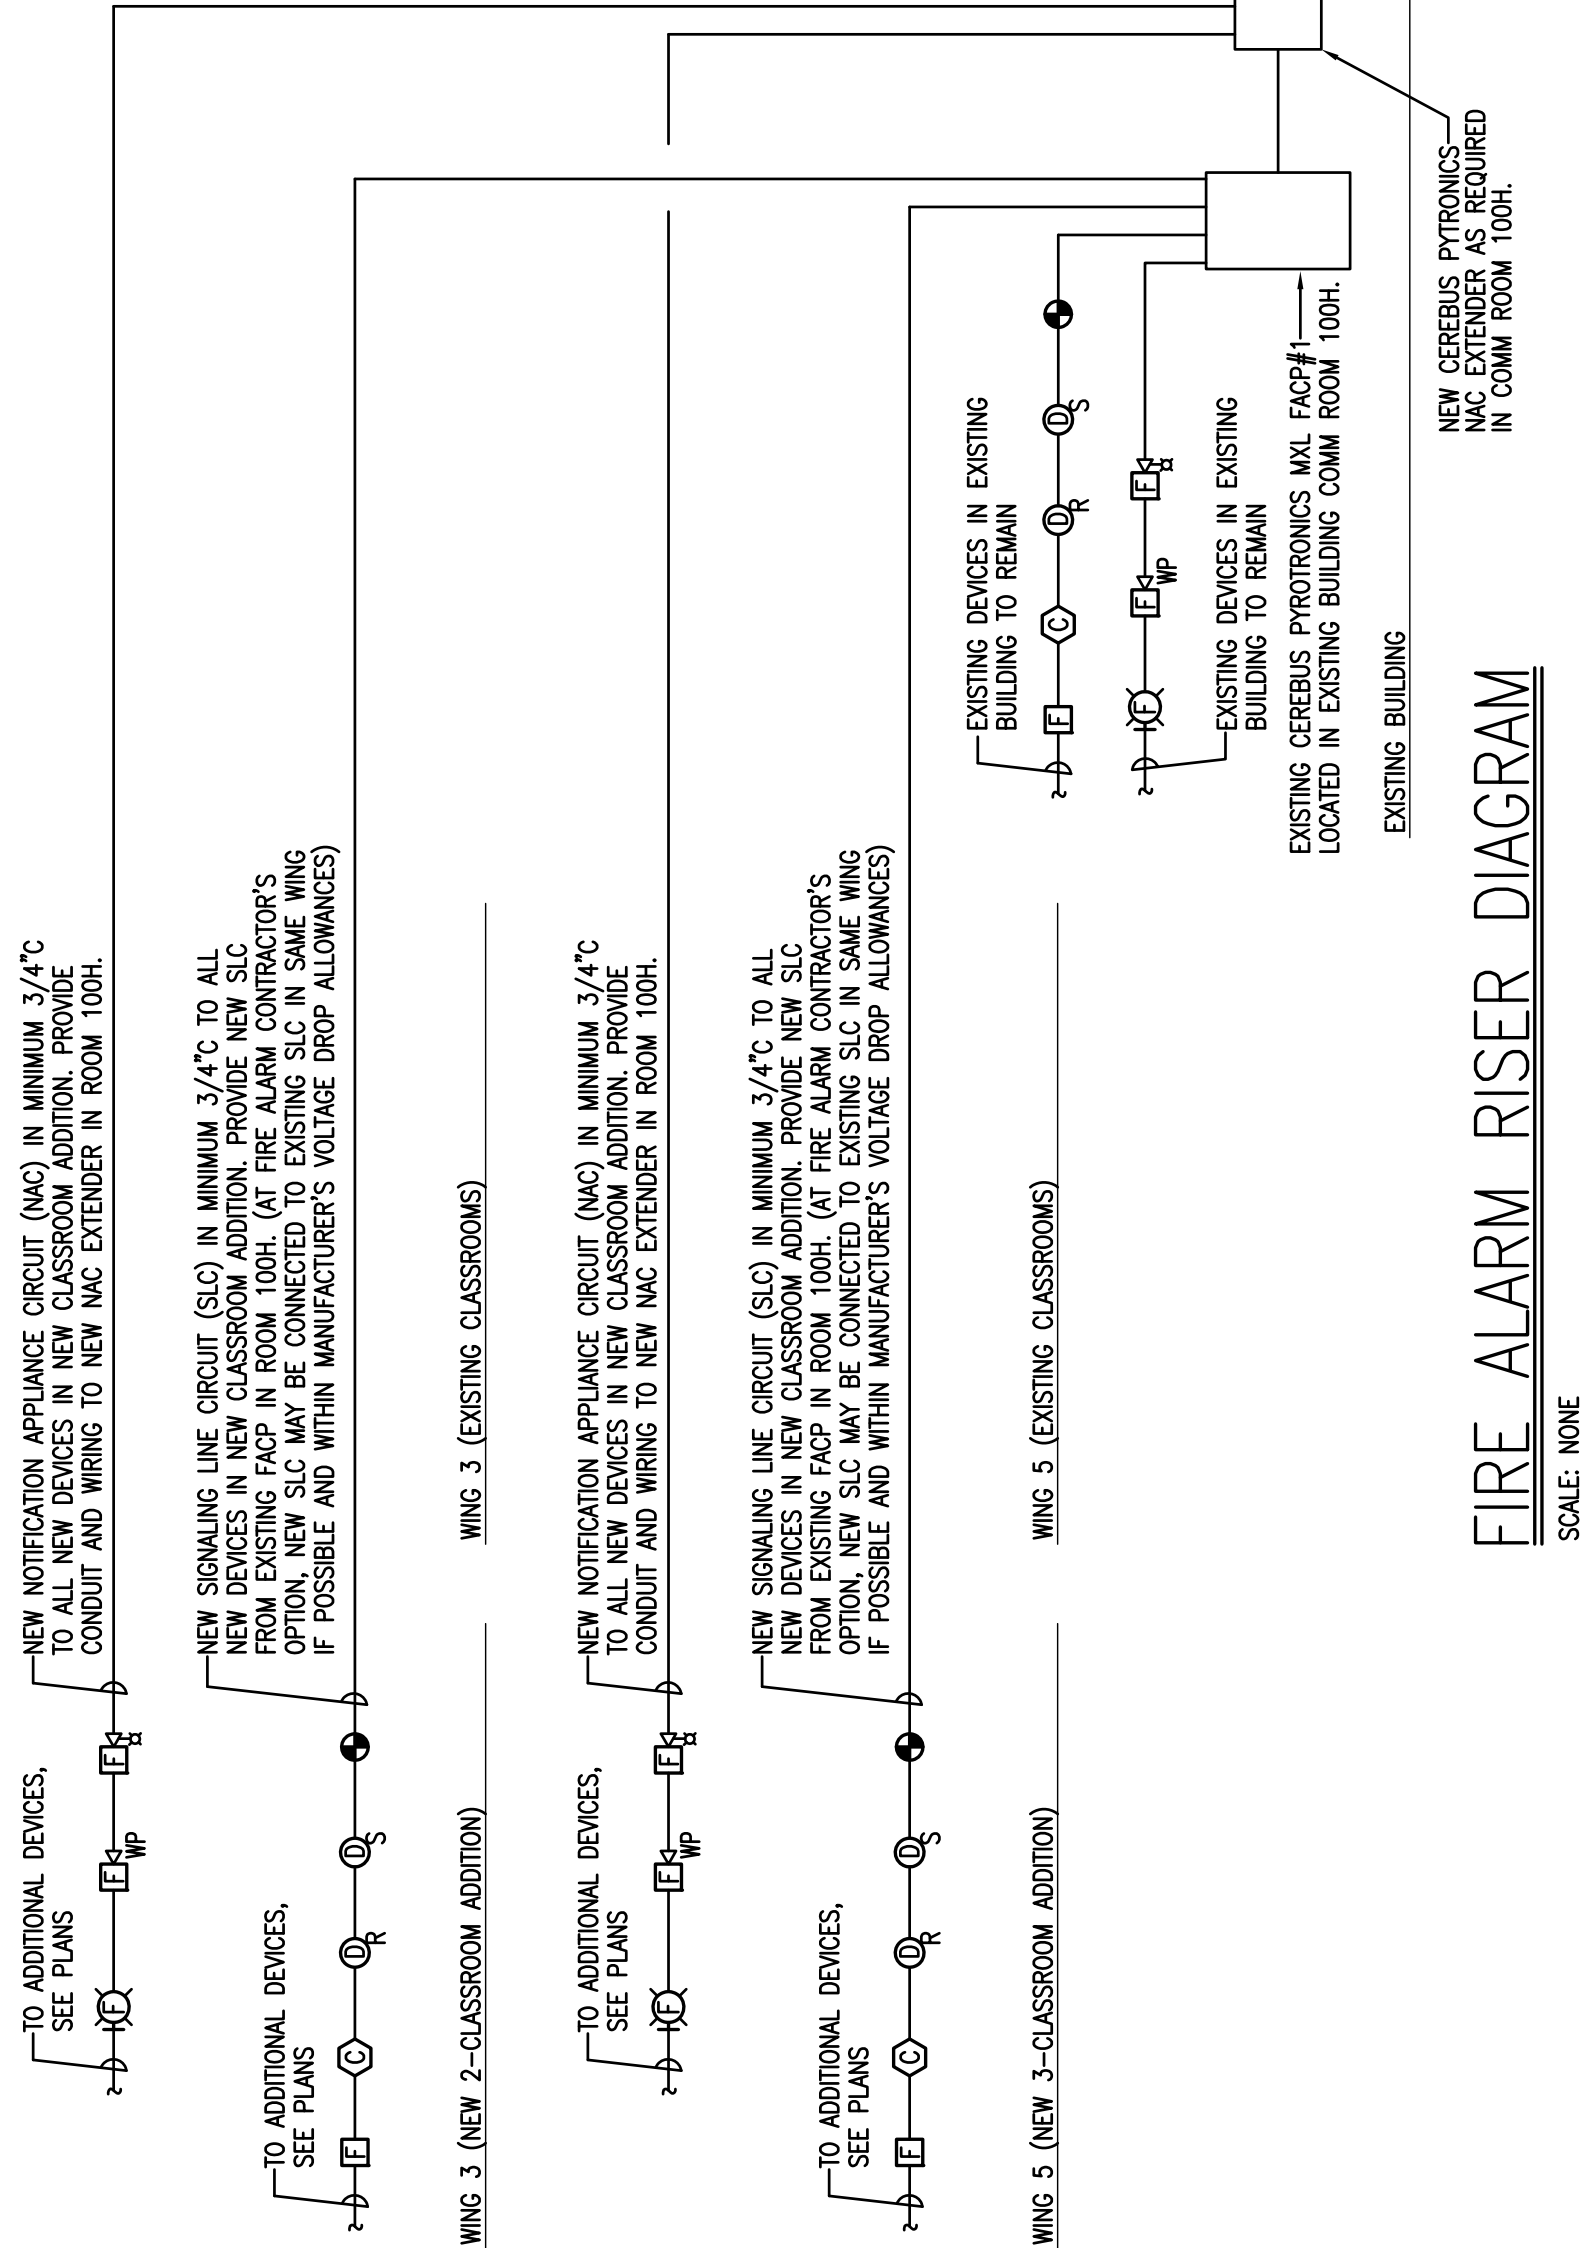


FIRE ALARM RISER DIAGRAM

SCALE: NONE

FIRE ALARM SYSTEM GENERAL NOTES


- IN ADDITION TO PROVIDING NEW DEVICES AS INDICATED ON THE PLANS, PROVIDE NEW POWER SUPPLIES, BATTERY CABINETS, NAC EXTENDERS, CHARGES, WIRING, ETC AS REQUIRED TO MAINTAIN A COMPLETELY FUNCTIONAL FIRE ALARM SYSTEM.
- ALL WIRING SHALL BE PER MANUFACTURER'S RECOMMENDATIONS. ALL FIRE ALARM SYSTEM WIRING SHALL BE INSTALLED IN CONDUIT. MINIMUM SIZE CONDUIT SHALL BE 3/4\"/>
- THE CONTRACTOR SHALL PERFORM A COMPLETE PREWORK INSPECTION AND TEST OF THE EXISTING FIRE ALARM SYSTEM PRIOR TO CONSTRUCTION. THE CONTRACTOR SHALL NOTIFY THE ARCHITECT AND OWNER IN WRITING OF ANY EXISTING TROUBLES OR ALARM CONDITIONS PRIOR TO CONSTRUCTION. ANY SUCH TROUBLES OR ALARM CONDITIONS PRESENT AT THE END OF CONSTRUCTION AND NOT LISTED IN THE PREWORK INSPECTION REPORT SHALL BE CORRECTED BY THE CONTRACTOR PRIOR TO OBTAINING SUBSTANTIAL COMPLETION.
- ALL FIRE ALARM SYSTEM WORK SHALL BE PERFORMED BY A STATE CERTIFIED FIRE ALARM SYSTEM CONTRACTOR AND SHALL BE IN ACCORDANCE WITH NFPA 70, NFPA 72, NFPA 101, ALL OTHER APPLICABLE NFPA CODES, THE FLORIDA BUILDING CODE, SREF, AND ALL STATE OR LOCAL CODES.
- ALL TERMINATIONS SHALL BE MADE ON TERMINAL STRIPS. SPICES SHALL BE PROHIBITED.
- THE CONTRACTOR SHALL PROVIDE ALL FIRE ALARM SYSTEM CONDUIT, JUNCTION BOXES, WIRING, NOTIFICATION APPLIANCES, INITIATING DEVICES, FIRE ALARM CONTROL PANEL(S), POWER SUPPLIES, ETC AS REQUIRED FOR A COMPLETE AND FUNCTIONAL FIRE ALARM SYSTEM AS INDICATED ON THE DRAWINGS AND IN THE SPECIFICATIONS. ALL FIRE ALARM SYSTEM WORK SHALL BE INCLUDED BY THE CONTRACTOR IN THE BASE BID OF THIS PROJECT.

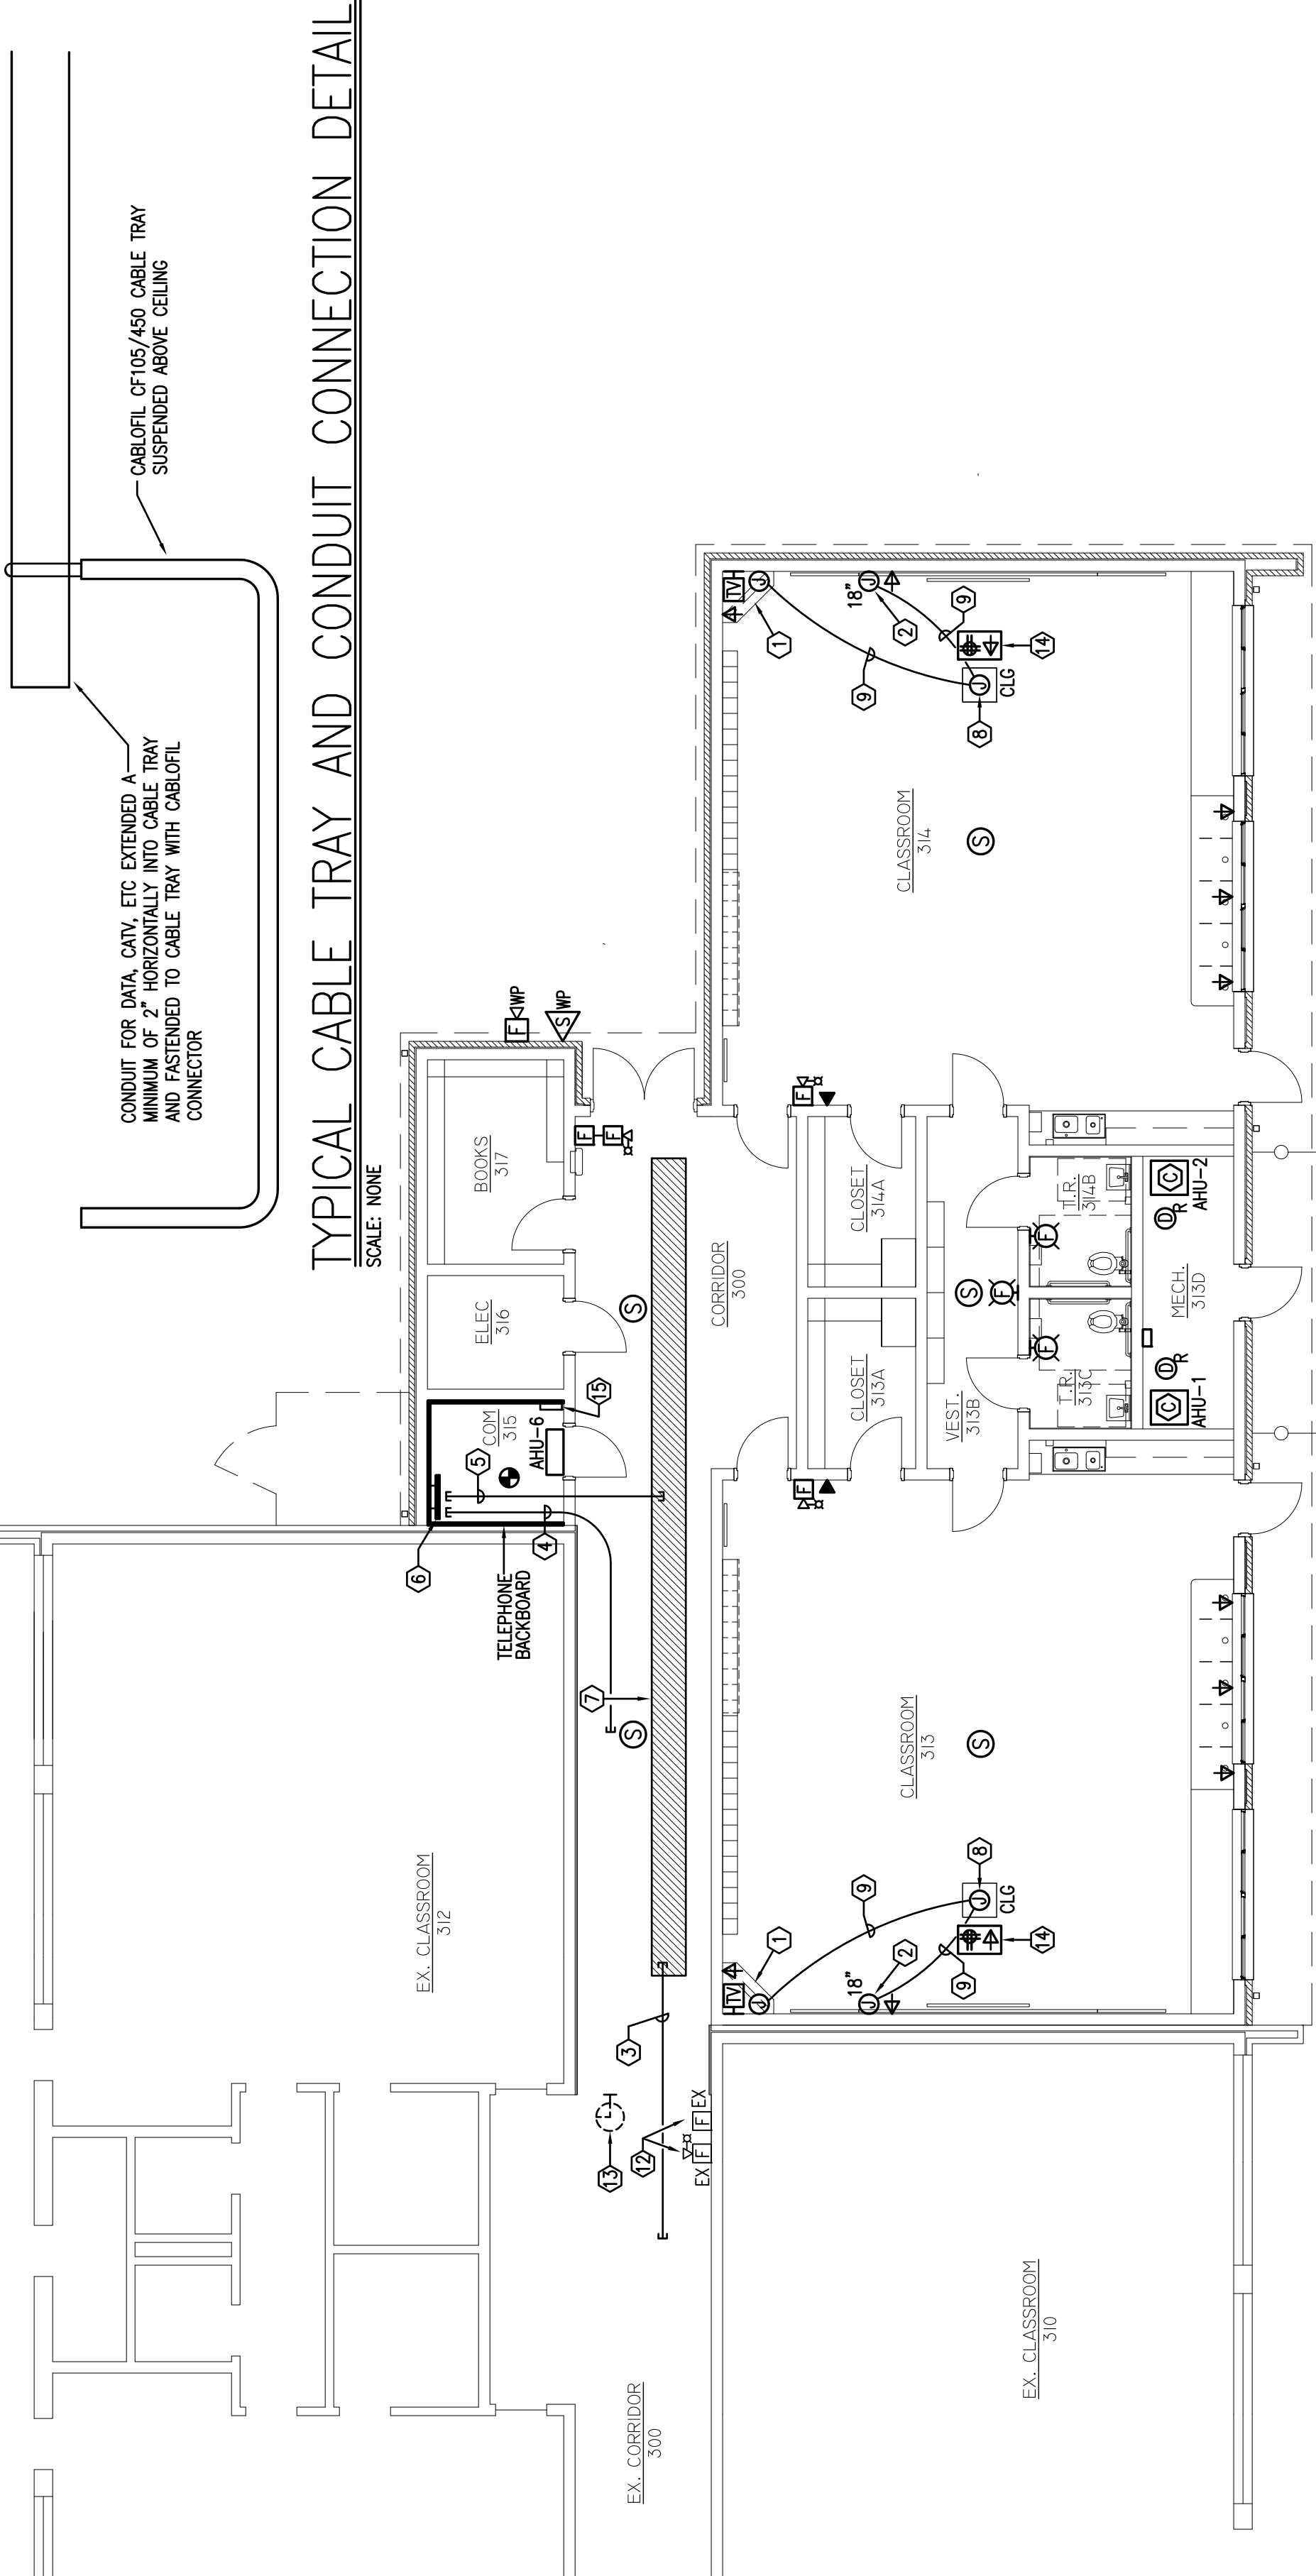

SIGNAL PLAN-WING 3

SCALE: 1/8" = 1'-0"

NOTE:
DO NOT SCALE DRAWINGS TO LOCATE ELECTRICAL DEVICES.
LOCATE ELECTRICAL DEVICES TO MATCH ELECTRICAL SYMBOLS.
REPORT CONFLICTS TO ARCHITECT PRIOR TO PROCEEDING.

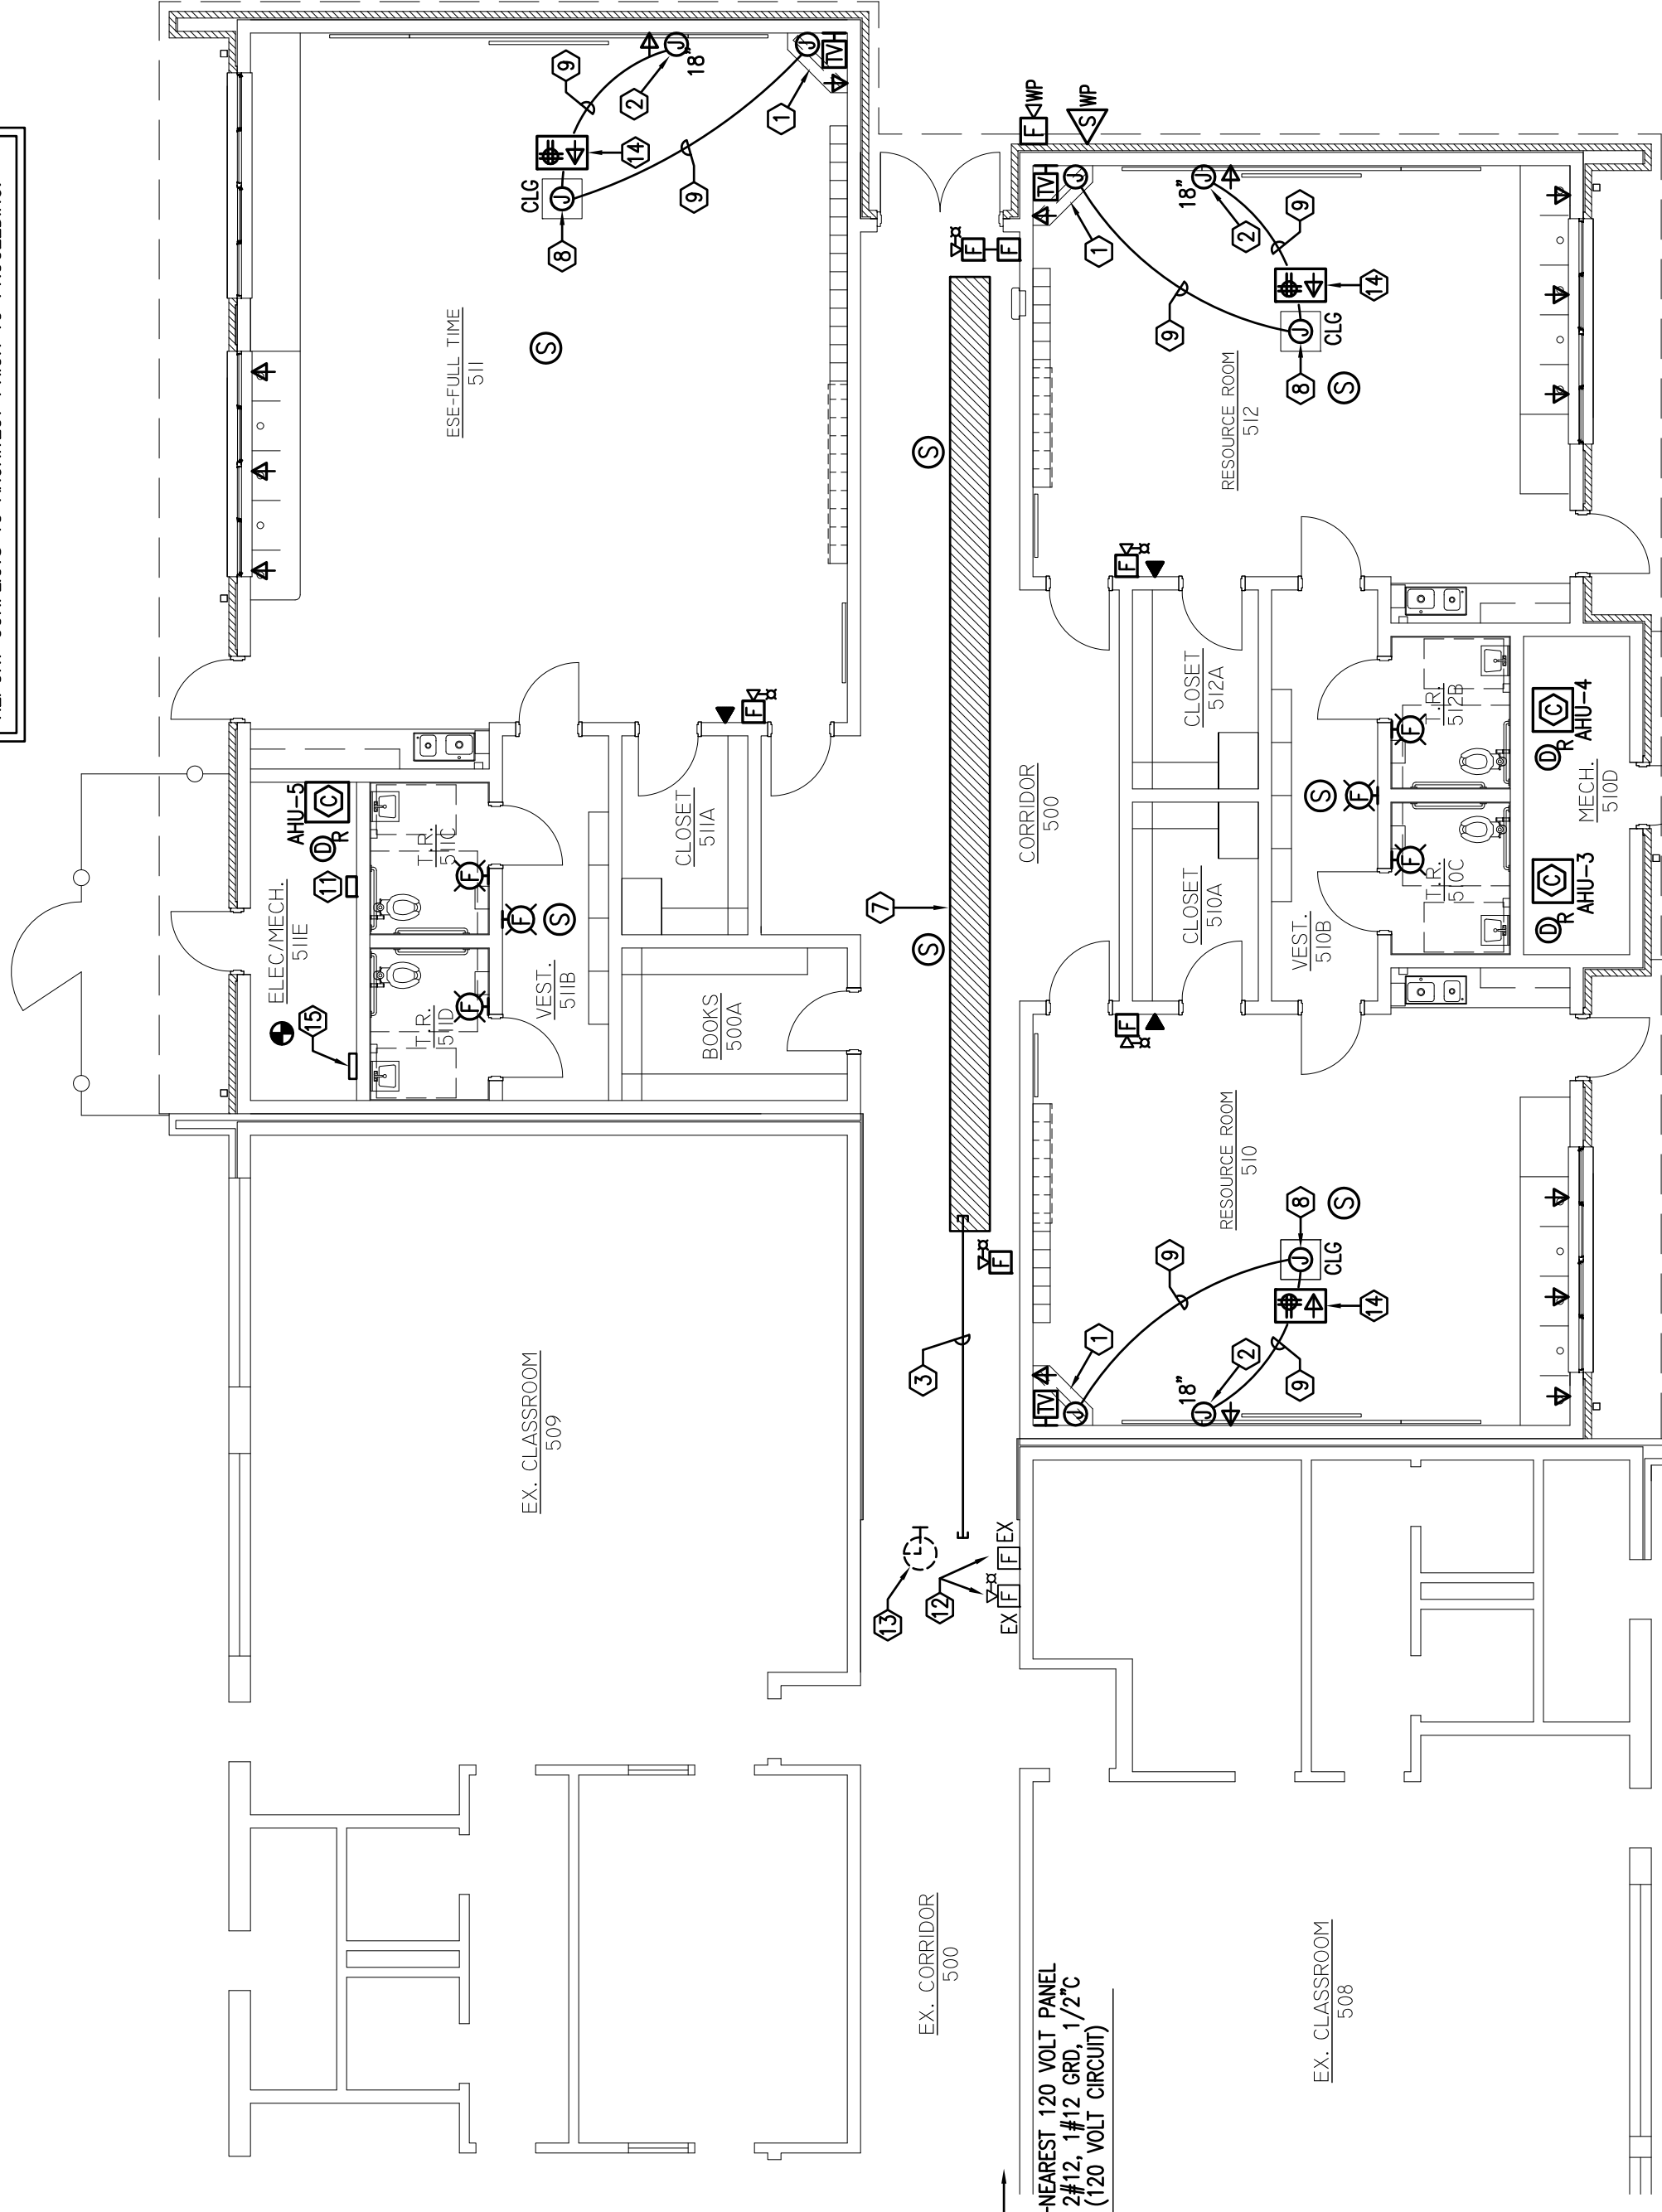

SIGNAL PLAN-WING 5

SCALE: 1/8" = 1'-0"




PINGERMARTIN ASSOCIATES, INC.
1001 N. 12th AVENUE
PENSACOLA, FL 32501
850-439-9110

A-200008986

PROJECT:
5 CLASSROOM ADDITION
LOCATION:
WEST NAVARRE INTERMEDIATE SCHOOL
1970 COTTON BAY LANE
NAVARRE, FL 32566

CONSULTANTS:
JEHL-HALSTEAD, INC.
48 EAST CHASE STREET
PENSACOLA, FL 32502
CRAFT & WEBSTER
12000 W. GULF BREEZE, FL 32581
129 HOBSON DRIVE
GULF BREEZE, FL 32581
GULF BREEZE CONSULTING, INC.
139 EAST GOVERNMENT STREET
PENSACOLA, FL 32502
ADAMS CONSULTING ENGINEERING, INC.
1000 W. GULF BREEZE, FL 32581
SUITE 302
PENSACOLA, FL 32502

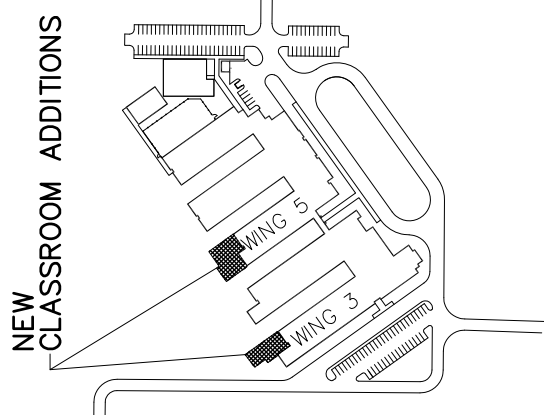

WEST NAVARRE INTERMEDIATE

No.	Revision/Issue	Date

SCOTT A. ADAMS
OWNER OF RECORD
PE 7949

DRAWN BY:
SAA
CHECKED BY:
SAA
PROJECT #:
PMA 2118.03
REVIEW:
08-08-11
PERMITTING:
08-08-11
RELEASE FOR BIDDING:
08-19-11

SIGNAL PLANS

E4.0
2118.03 E4.0

ADAMS CONSULTING ENGINEERING, INC.
3 W GARDEN ST. SUITE 382
PENSACOLA, FL 32502
PH (850) 444-0095 FLORIDA CA No. 26311
SCOTT A. ADAMS, P.E. FL LICENSE No. 57949