

PROJECT:
5 CLASSROOM ADDITION

LOCATION:
WEST NAVARRE INTERMEDIATE
SCHOOL
1970 COTTON BAY LANE
NAVARRE, FL 32566

CONSULTANTS:


JEHLE-HALSTEAD, INC.
49 EAST CHASE STREET
PENSACOLA, FL 32502

CRAFT & WEBSTER
STRUCTURAL ENGINEERING, INC.
129 HIGHTOWER DRIVE
GULF BREEZE, FL 32561

GULF BREEZE CONSULTING, INC.
139 EAST GOVERNMENT STREET
PENSACOLA, FL 32502

ADAMS CONSULTING
ENGINEERING, INC.
3 WEST GARDEN STREET - SUITE 382
PENSACOLA, FL 32502

**NEW
CLASSROOM ADDITIONS**

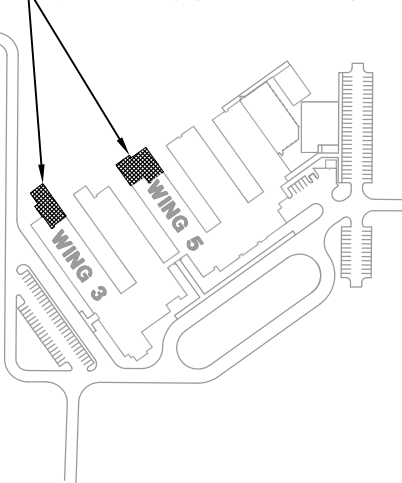

**WEST NAVARRE
INTERMEDIATE**


No.	Revision/Issue	Date

KENNETH L. GONZALEZ
ENGINEER OF RECORD
PE 61015

DRAWN BY: KMJS
CHECKED BY: KLG
PINDER-MARTIN ASSOCIATES, INC.
PROJECT #: 21118.03
REVIEW: 09-06-11
PERMITTING: 09-09-11
RELEASE FOR BIDDING: 09-19-11


**NEW WORK
FLOOR PLAN
WING 5**

P1.2

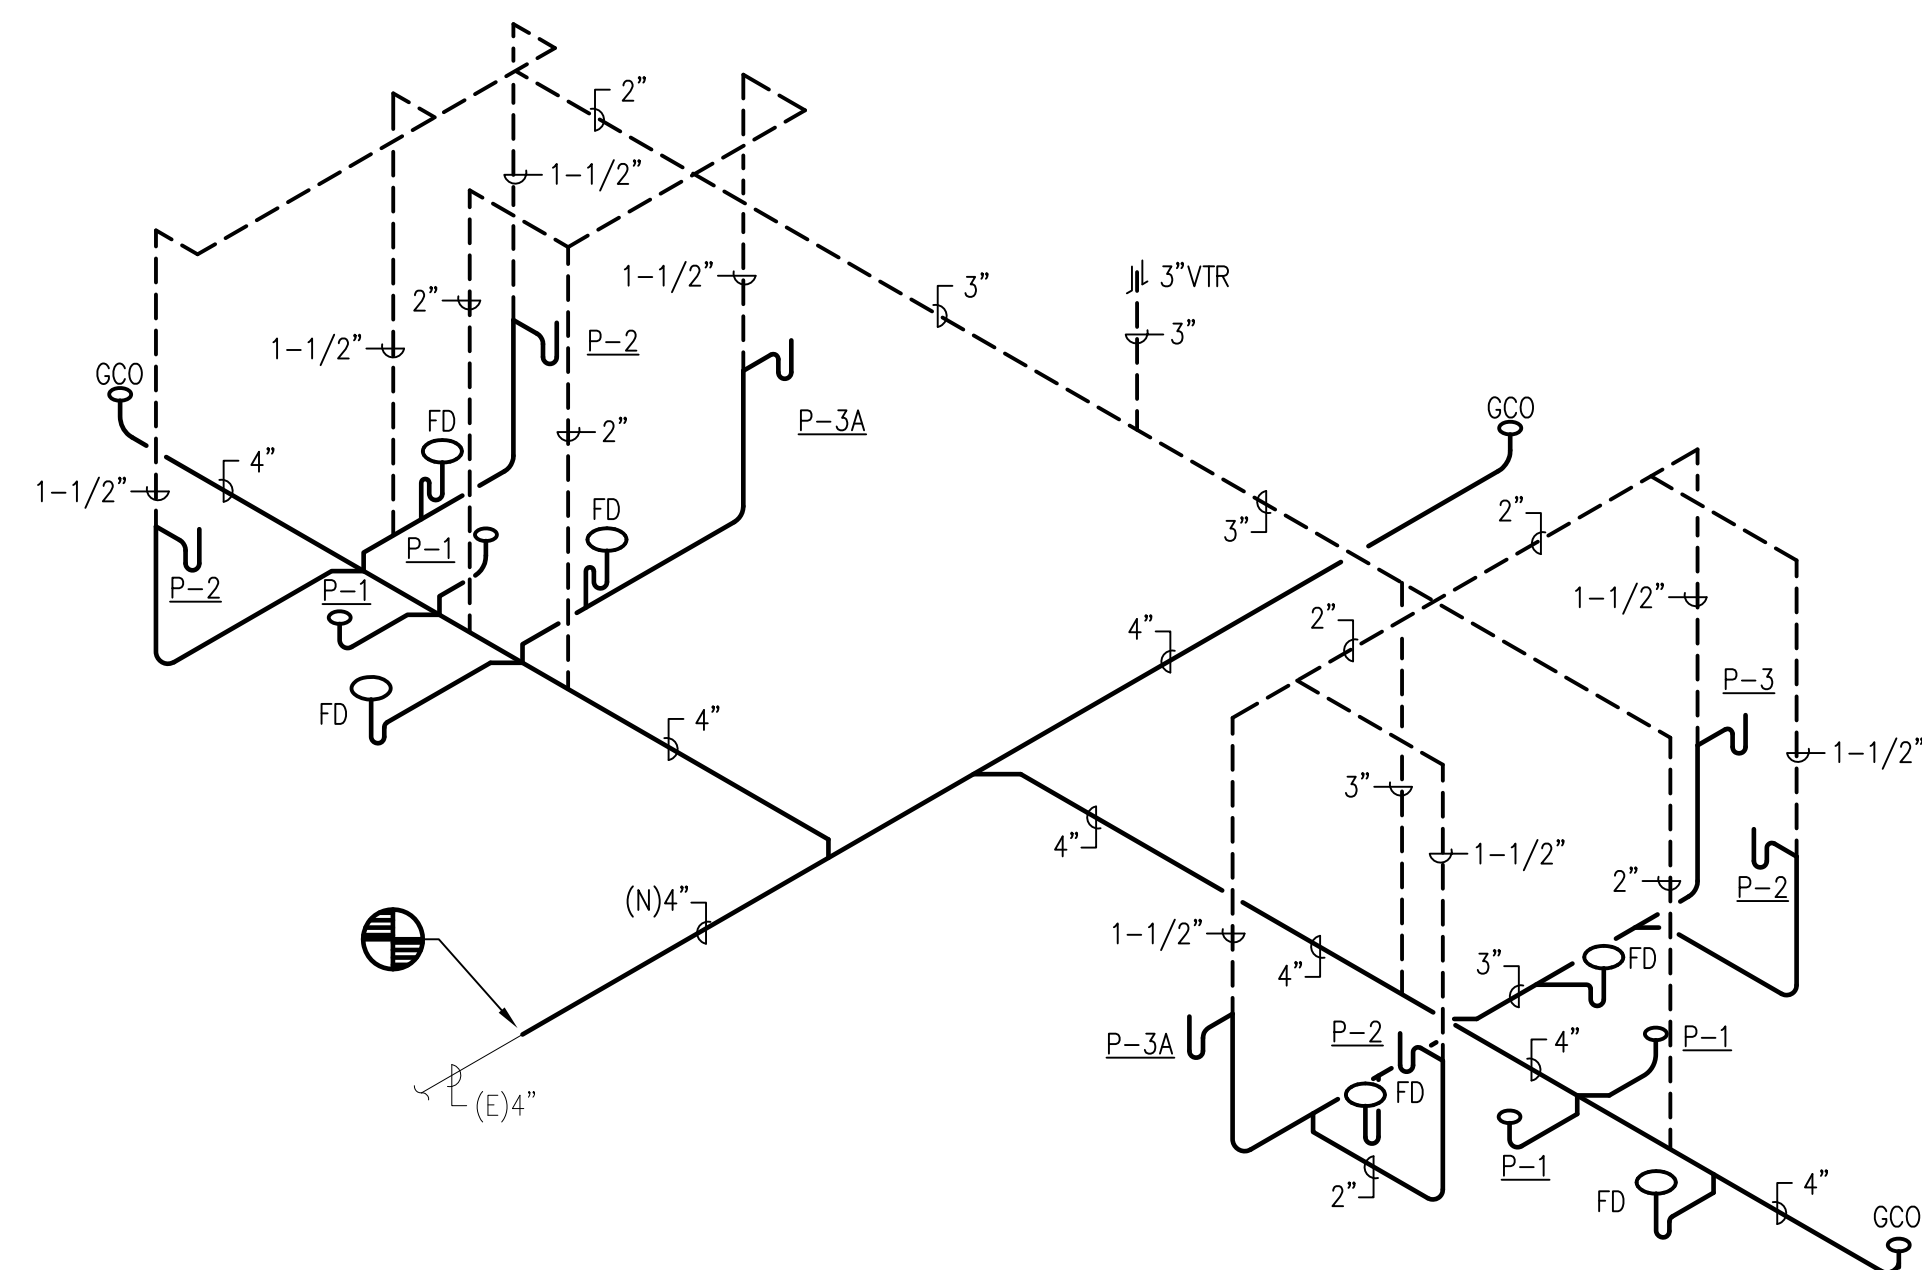

SANITARY SEWER RISER DIAGRAM

NOT TO SCALE


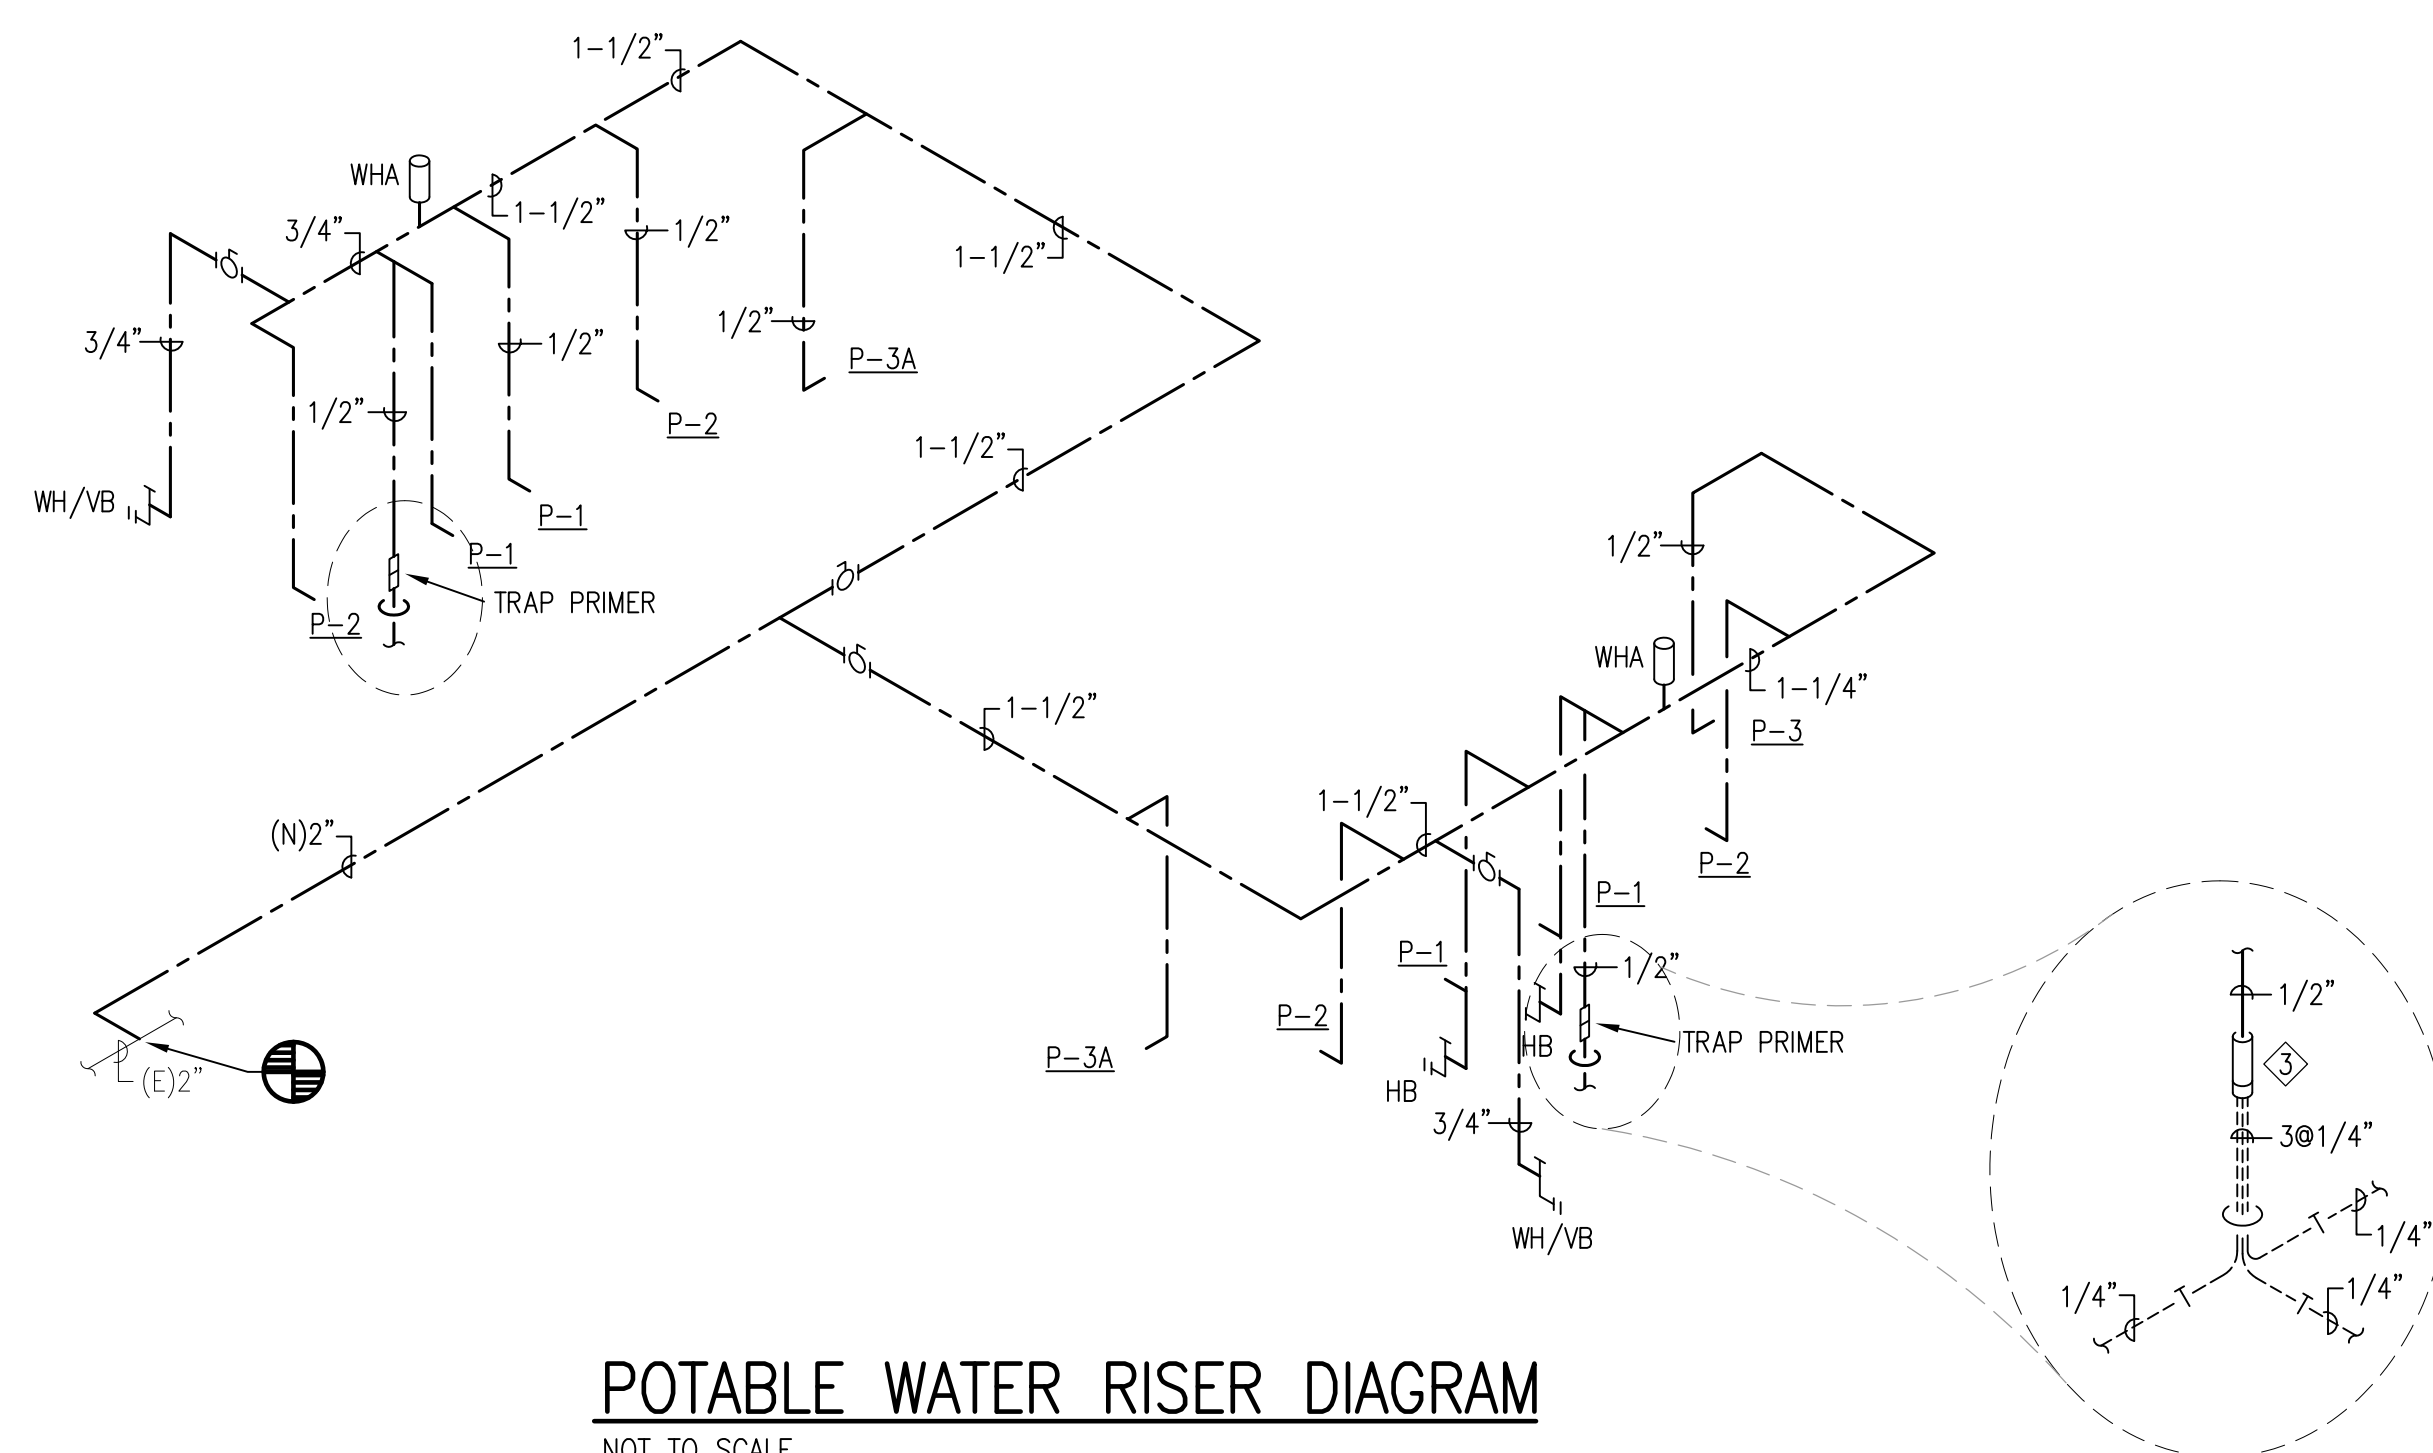


POTABLE WATER RISER DIAGRAM

NOT TO SCALE

NEW WORK KEY NOTES

- VENT THRU ROOF, MAINTAIN MINIMUM 10'-0" CLEARANCE FROM AND OUTSIDE AIR INTAKE.
- NON-FREEZE WALL HYDRANT SHALL BE PROVIDED WITH CHROME PLATED ROUGH CAST BRONZE BOX, HINGED COVER AND ACCESS KEY.
- PROVIDE SIOUX CHIEF MODEL 698-01 TRAP PRIMER WITH MODEL 695-D30 SPLITTER, ROUTE PIPING UNDER SLAB TO FLOOR DRAINS.
- FINAL LOCATION OF FLOOR DRAIN SERVING HVAC UNITS TO BE APPROXIMATELY 10" FROM BACK OF MECHANICAL ROOM WALL.
- REMOVE EXISTING GRADE CLEANOUT AND TIE NEW SANITARY SEWER PIPING INTO EXISTING SANITARY SEWER PIPING BELOW GRADE. VERIFY EXACT SIZE, LOCATION AND INVERT PRIOR TO INSTALLATION OF ANY PIPE.
- TAP NEW 2" POTABLE WATER PIPING INTO EXISTING 2" POTABLE WATER PIPING ABOVE CEILING. VERIFY EXACT SIZE AND LOCATION PRIOR TO INSTALLATION.

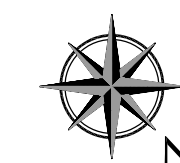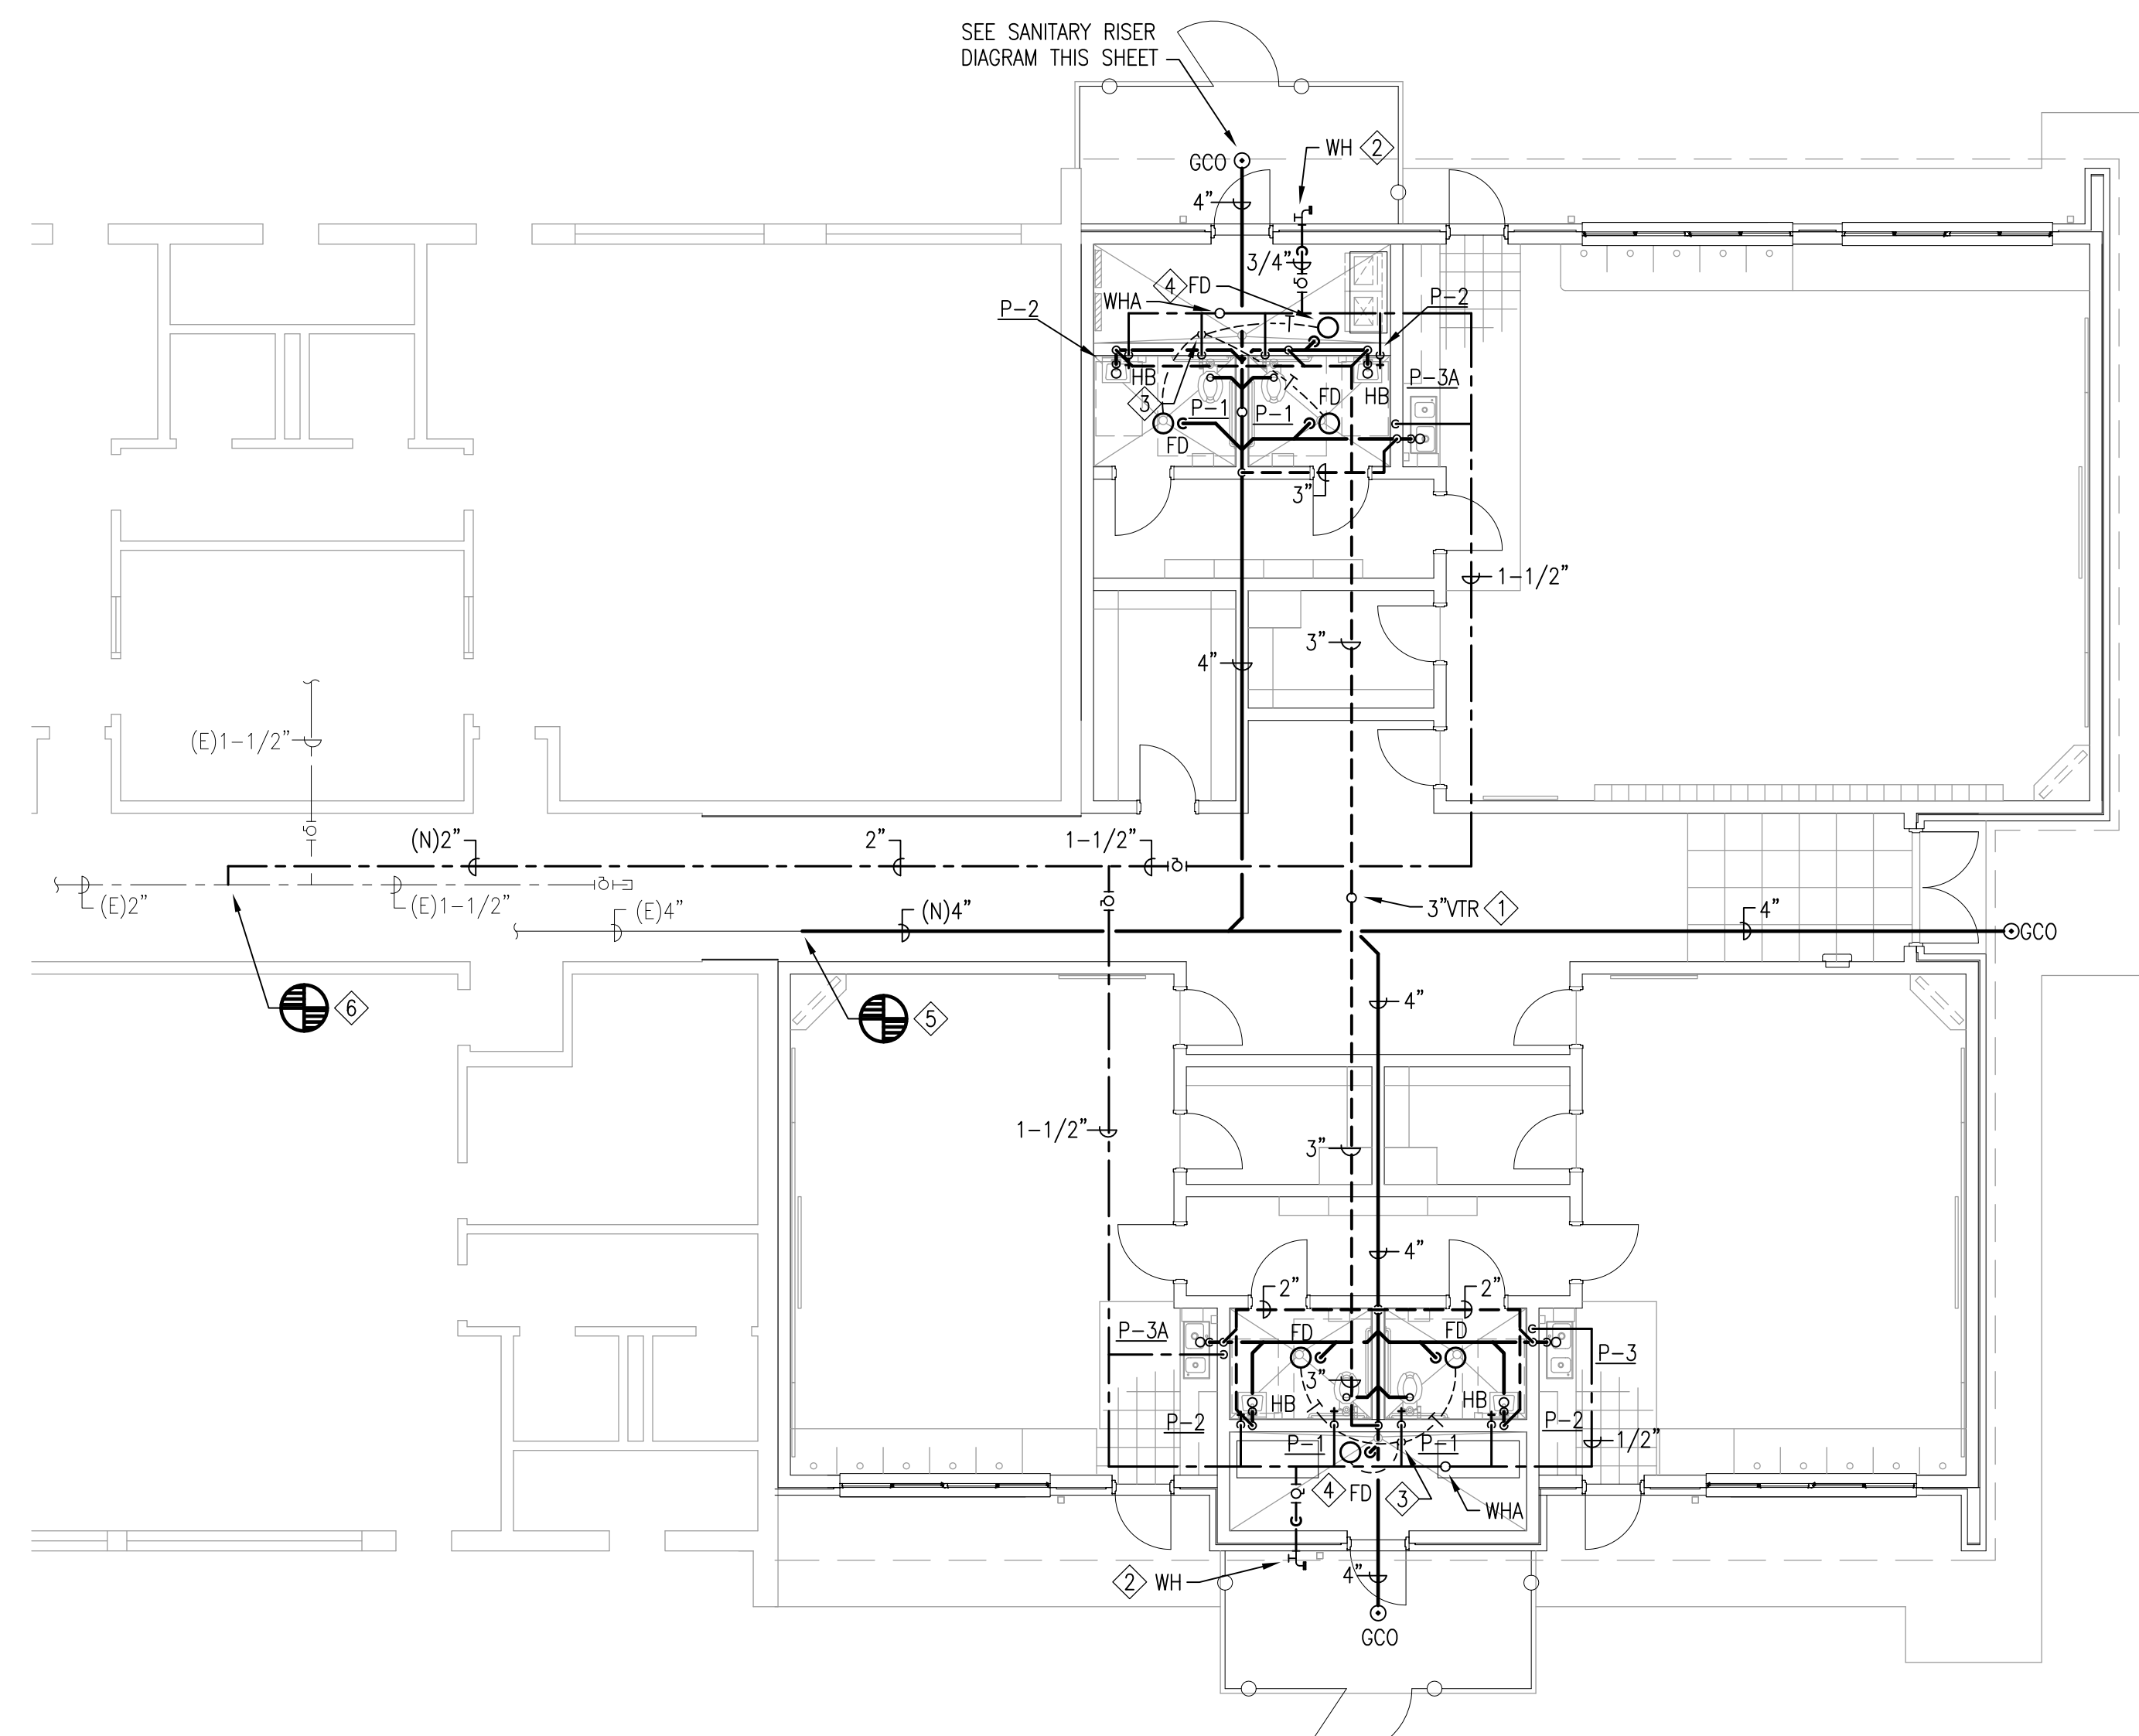

NEW WORK HVAC PLAN - WING 5

SCALE: 1/8"=1'-0"

GULF BREEZE CONSULTING, INC.

139 East Government
Pensacola • FL • 32502 • 850.453.6630



CA#-9836