



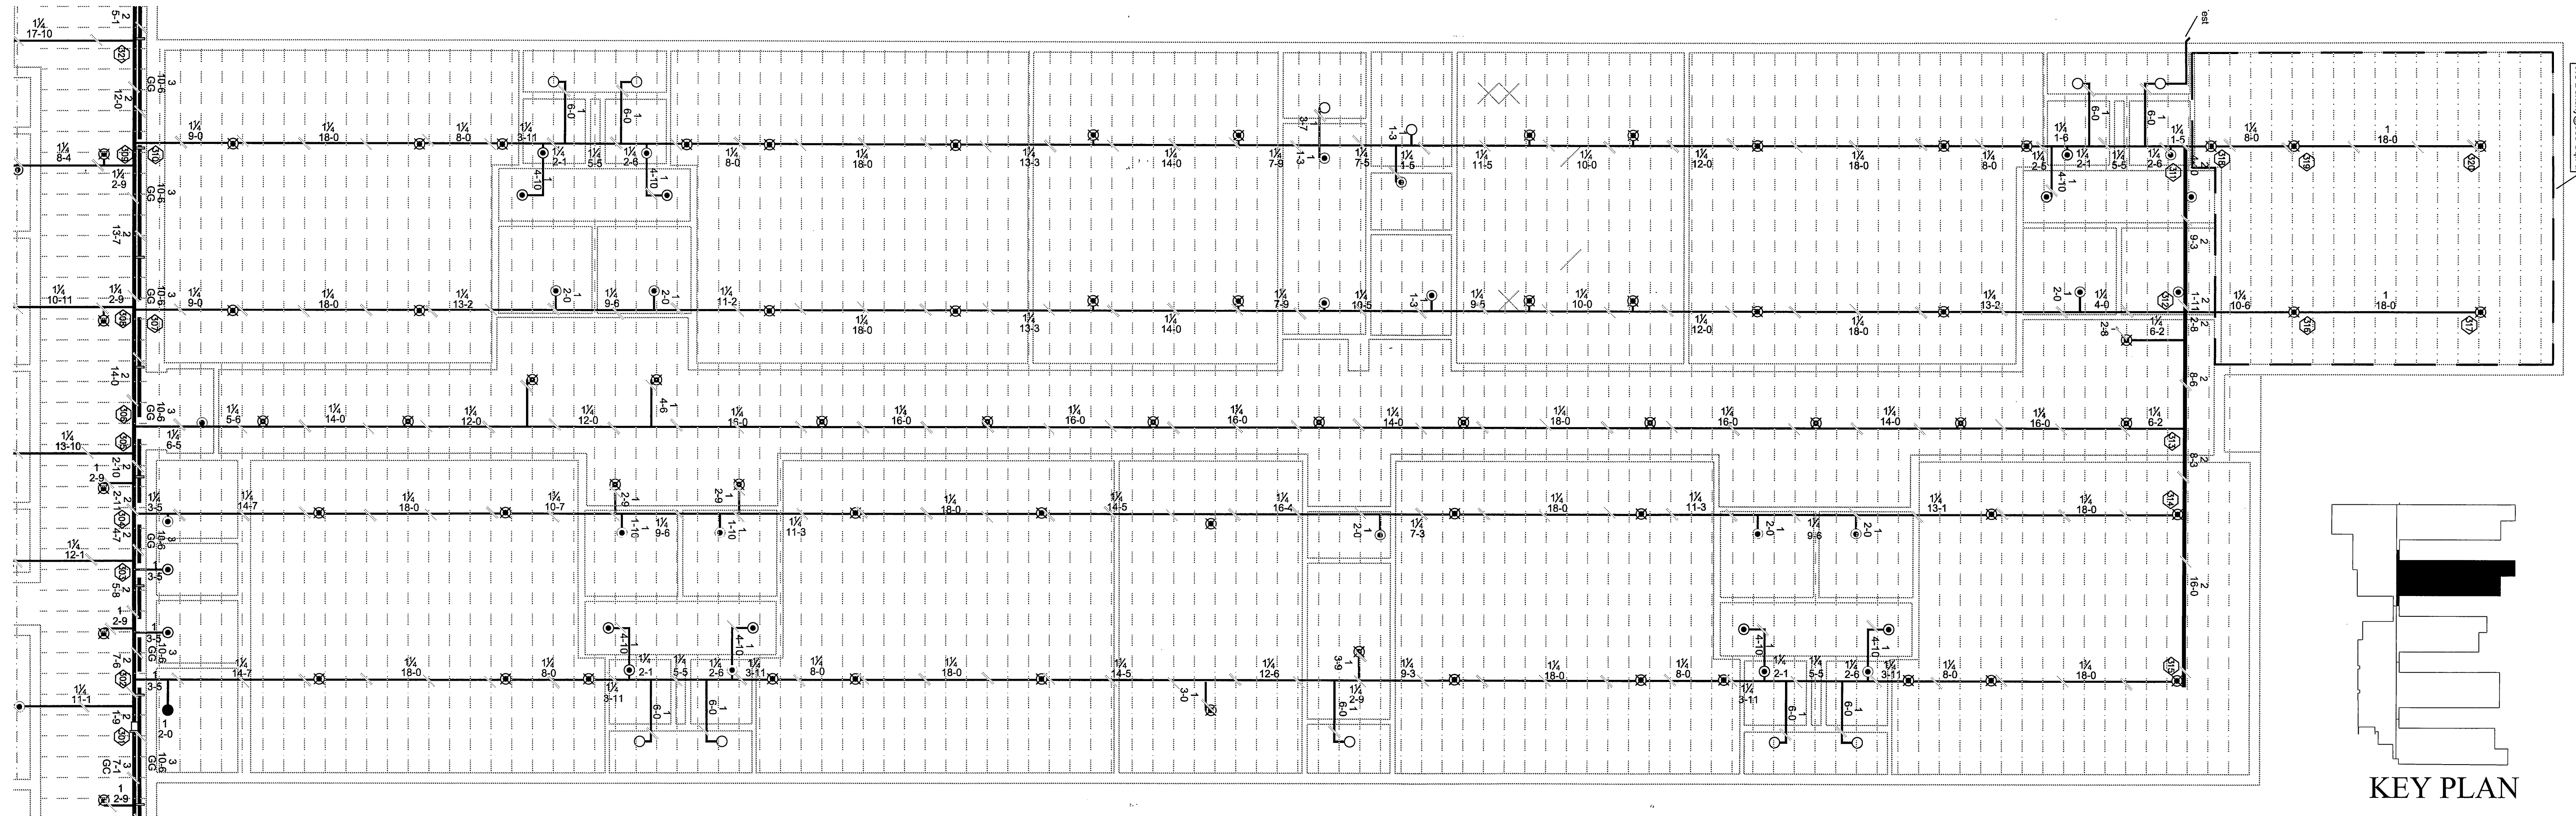

Classroom Wing #400 Piping Plan

Scale: 1/8"=1'-0"

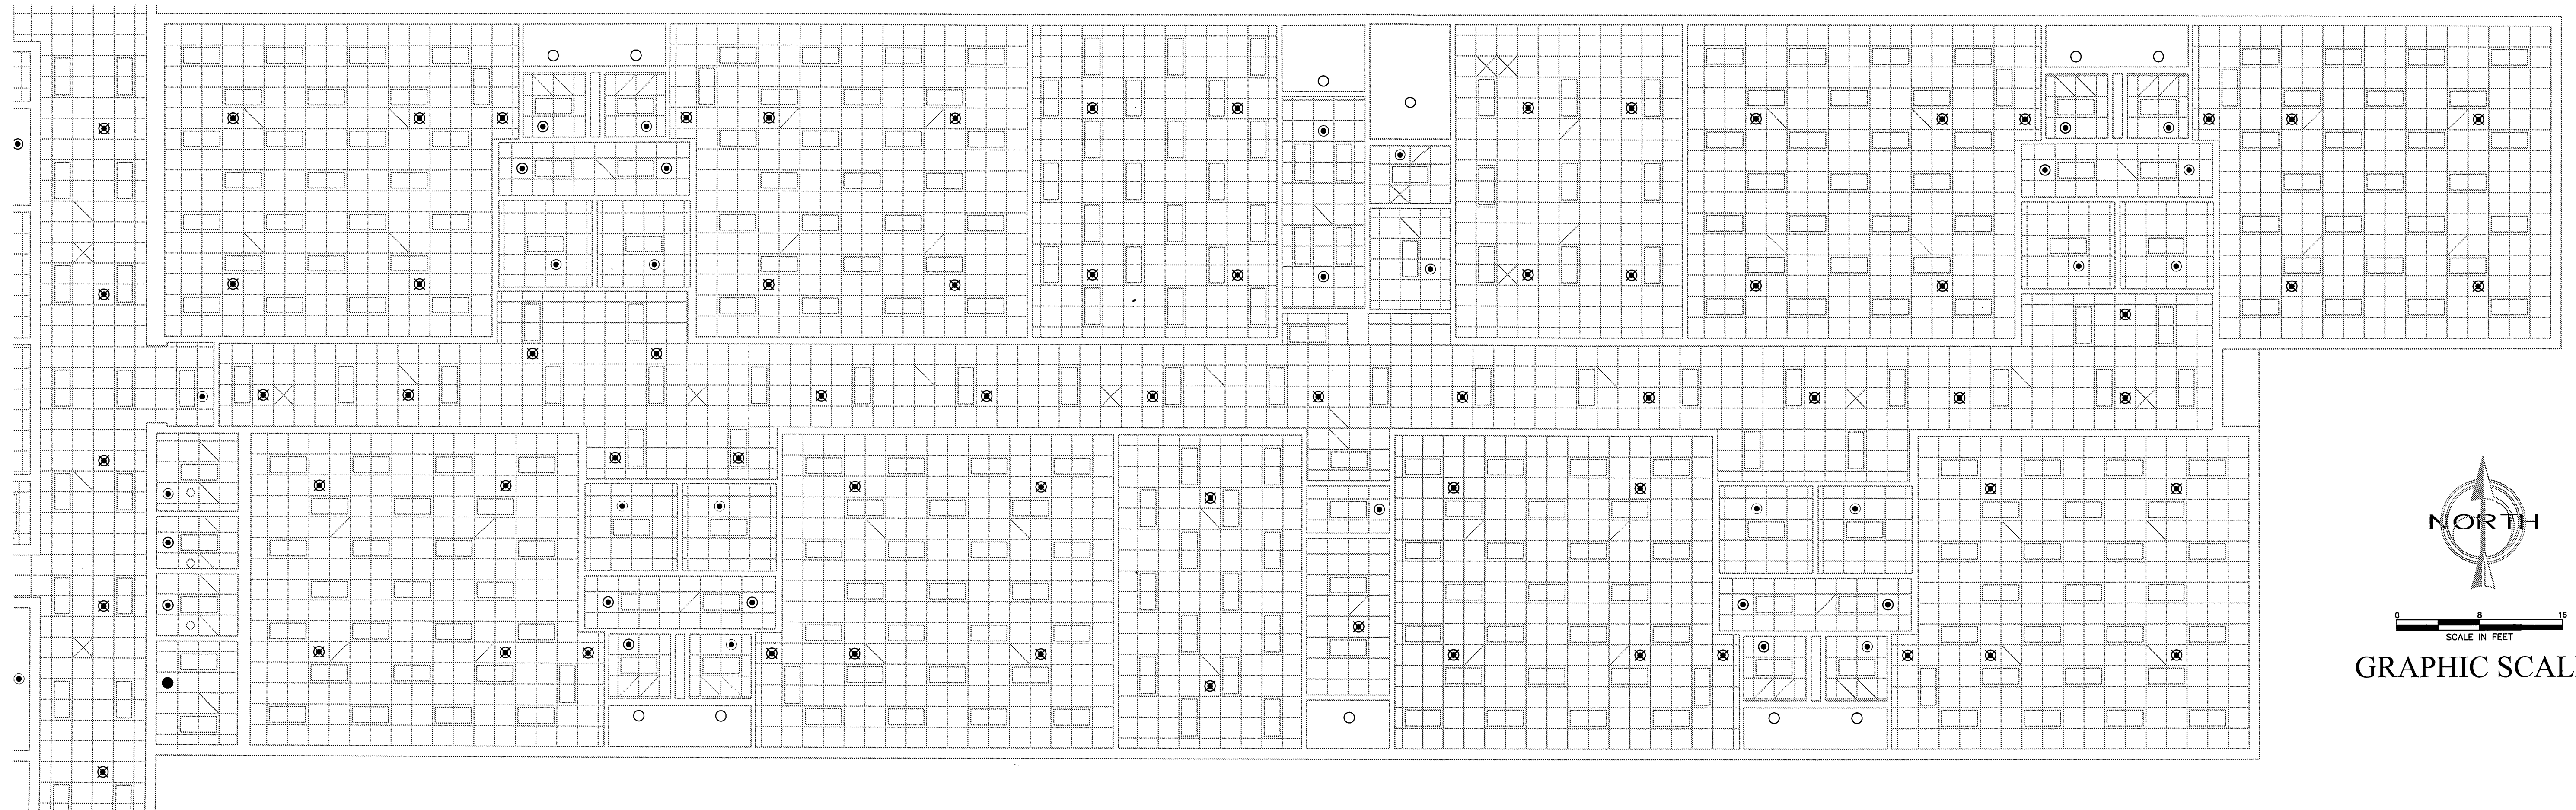

Classroom Wing #400 Reflected Ceiling Plan

Scale: 1/8"=1'-0"



KEY PLAN



SCALE IN FEET
0 8 16

GRAPHIC SCALE

REVISIONS

P.O. Box 7646
Pensacola, FL 32534
(850)-206-3269
Fax (850)956-0206



SEAL:

West Navarre
Intermediate
School

1970 Cotton Bay Lane
Navarre, Florida 32566

SHEET TITLE:

Classroom Wing
#400 Piping Plan

DRAWN BY: MAT
CHECKED BY: SJN
APPROVED BY:
PROJECT NO: 11-018
DATE: 2-24-11

SHEET

FP5