


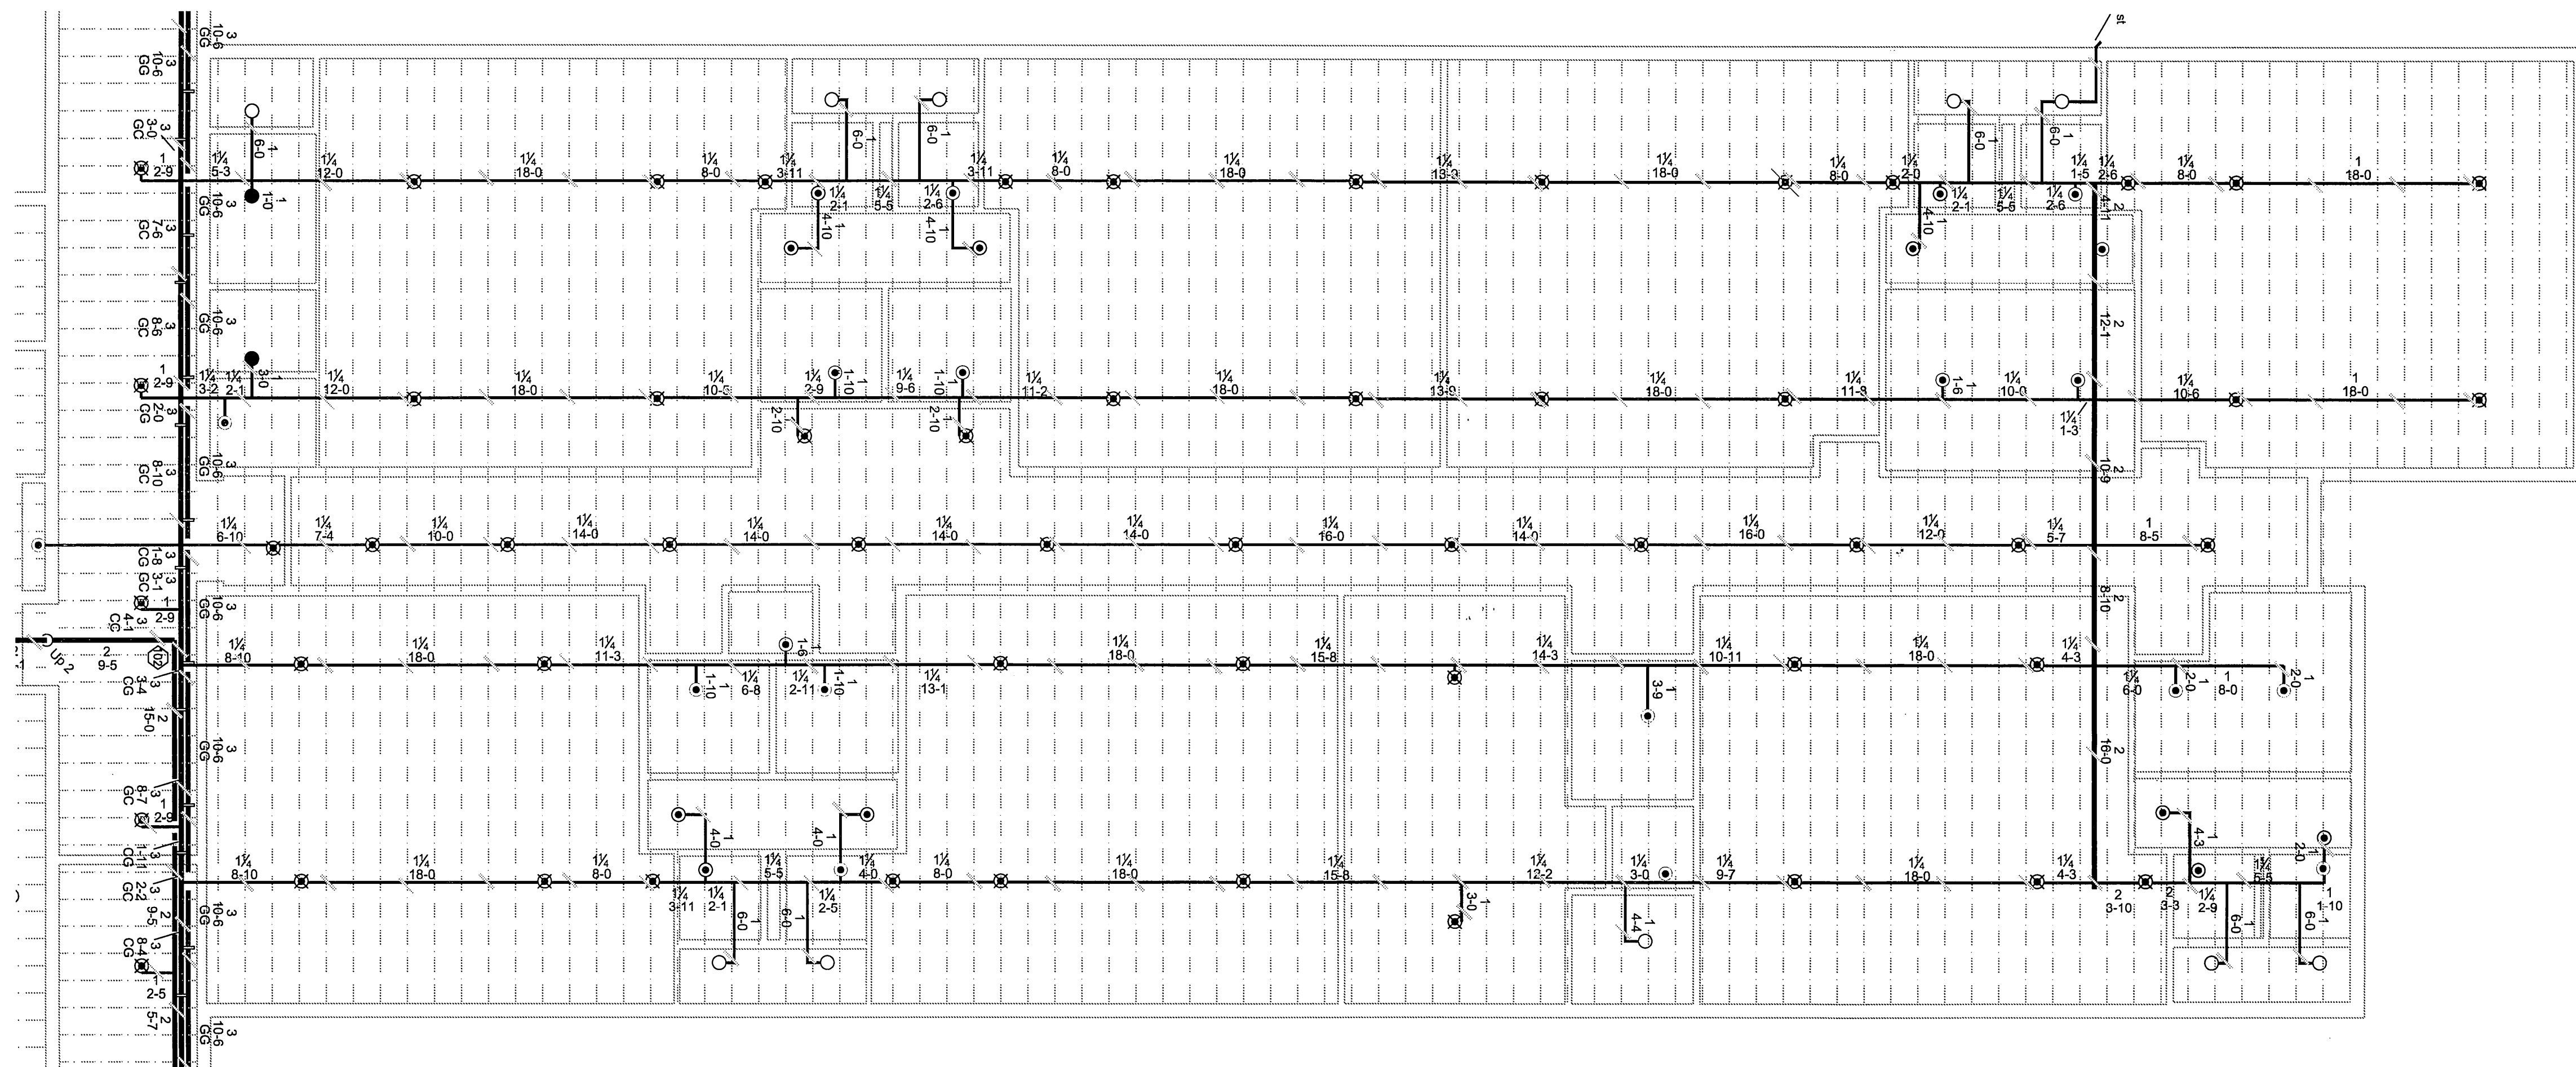


Classroom Wing #500 Piping Plan

Scale: $1/8"=1'-0"$



KEY PLAN

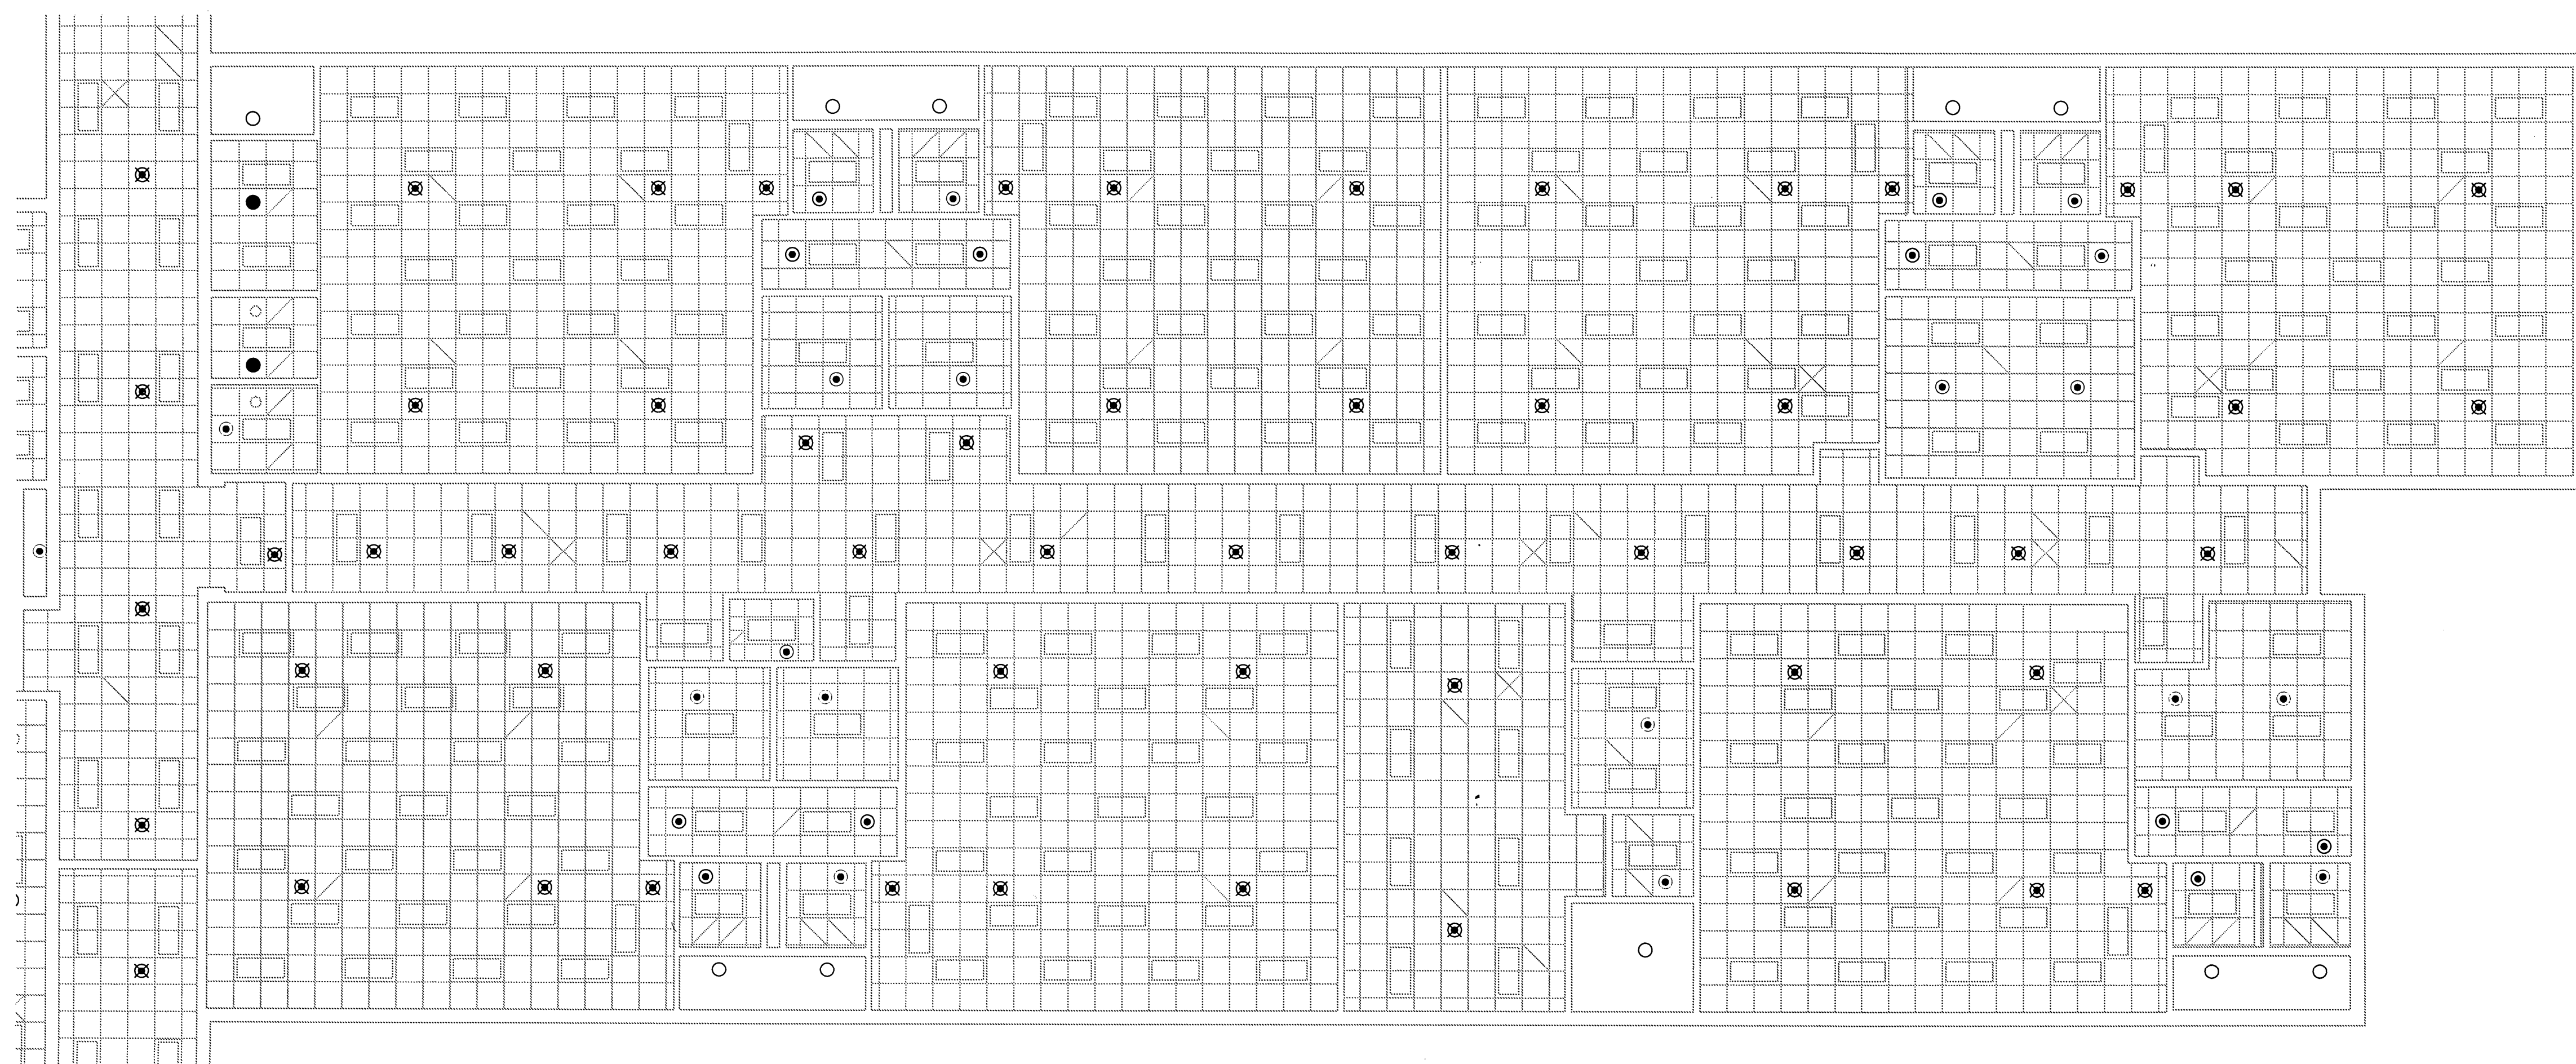

Classroom Wing #500 Reflected Ceiling Plan

Scale: $1/8"=1'-0"$

[illegible]

P.O. Box 7646
Pensacola, FL 32534
(850)-206-3269
Fax (850)958-0206



SEAL:

West Navarre
Intermediate
School

1970 Cotton Bay Lane
Navarre, Florida 32566

SHEET TITLE:

Classroom Wing
#500 Piping Plan

DRAWN BY: MAT
CHECKED BY: SJN
APPROVED BY:
PROJECT NO: 11-018
DATE: 2-24-11

SHEET

FP6



0 8 16
SCALE IN FEET

GRAPHIC SCALE