



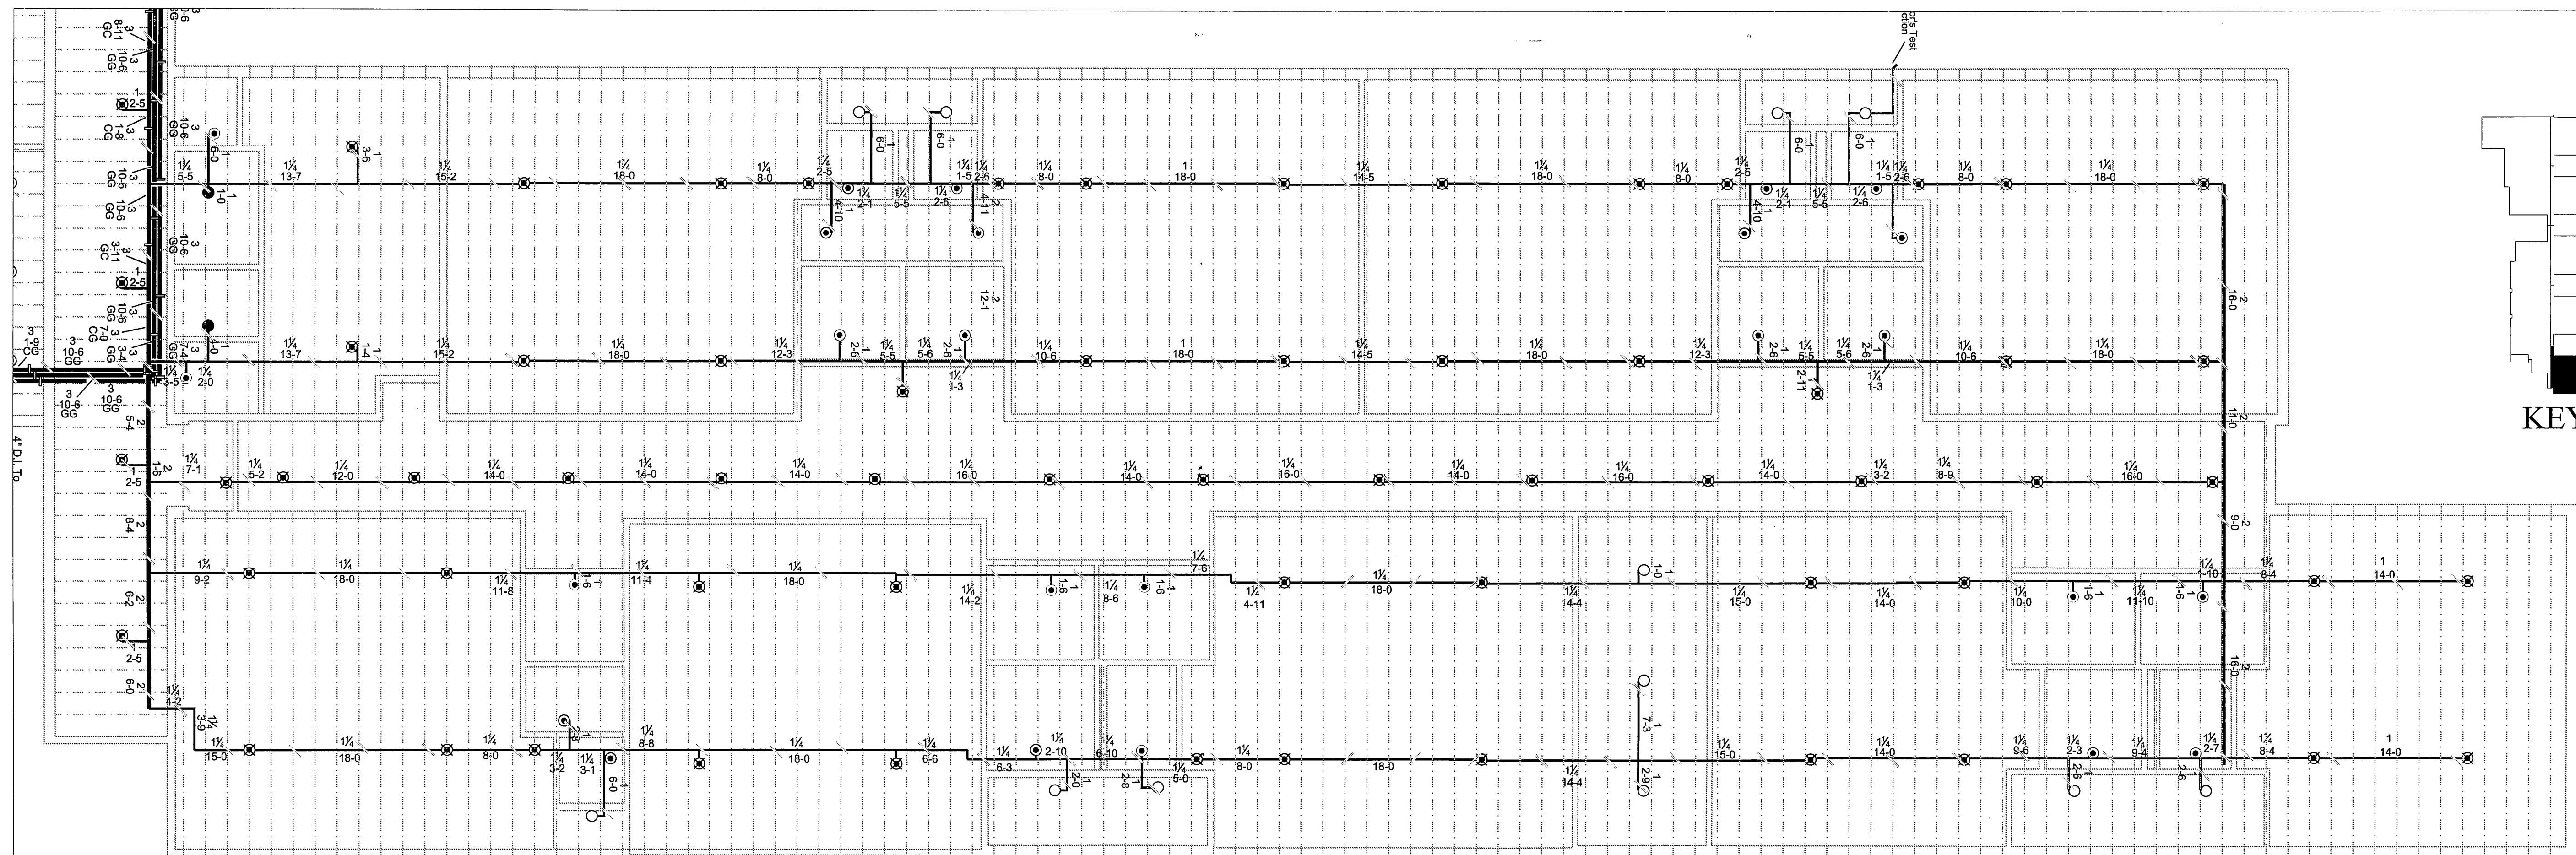


Classroom Wing #700 Piping Plan

Scale: 1/8"=1'-0"

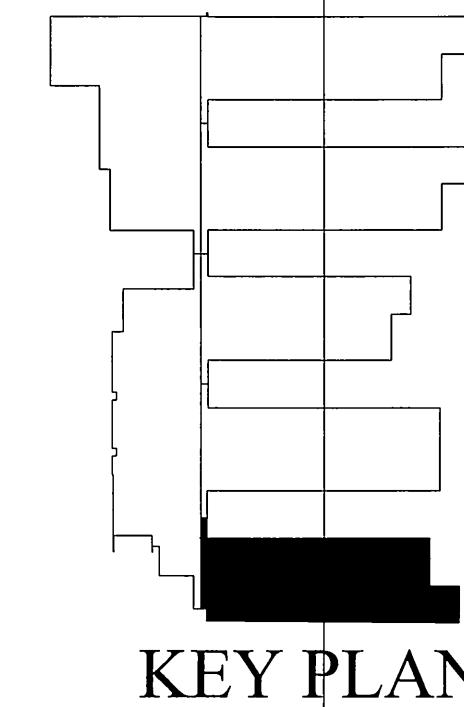


KEY PLAN

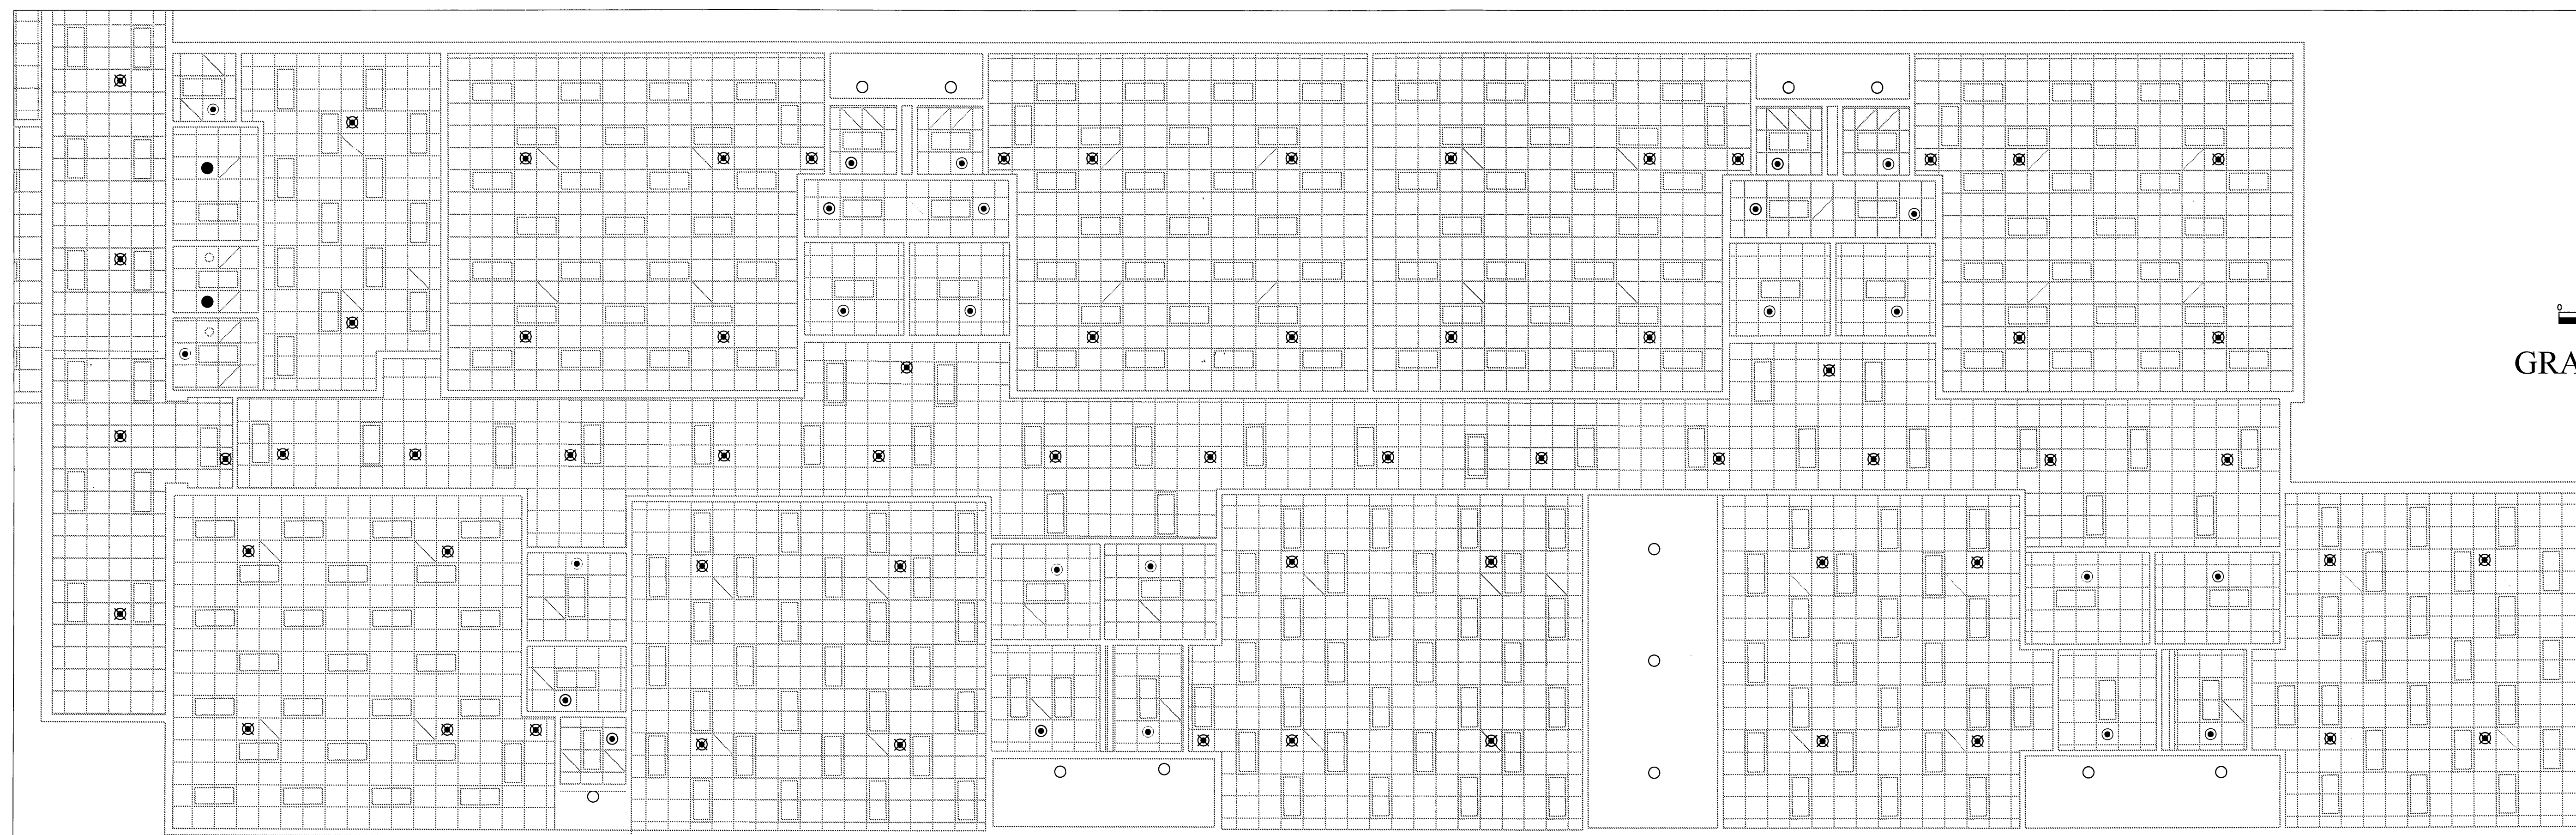

Classroom Wing #700 Reflected Ceiling Plan


Scale: 1/8"=1'-0"

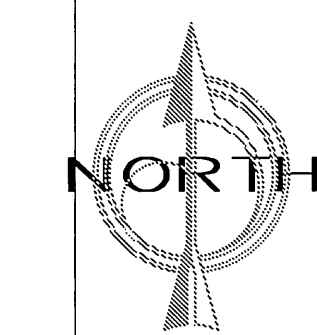

GRAPHIC SCALE

REVISIONS

P.O. Box 7646
Pensacola, FL 32534
(850) 206-3269
Fax (850) 958-0206

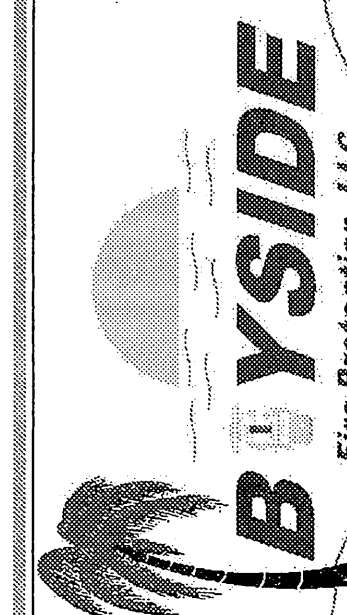

SEAL:

**West Navarre
Intermediate
School**

1970 Cotton Bay Lane
Navarre, Florida 32566

SHEET TITLE:

**Classroom Wing
#700 Piping Plan**

DRAWN BY: MAT
CHECKED BY: SJN
APPROVED BY:
PROJECT NO: 11-018
DATE: 2-24-11

SHEET

FP8